


NEW RESIDENCE FOR
MR. MICHAEL BEVILACQUA
LOT #10, BLOCK 20, 5 JERSEY CITY AVE.
LAVALLETTE, NJ 08735

REFLECTED CEILING
ELECTRICAL PLAN

FIRST FLOOR

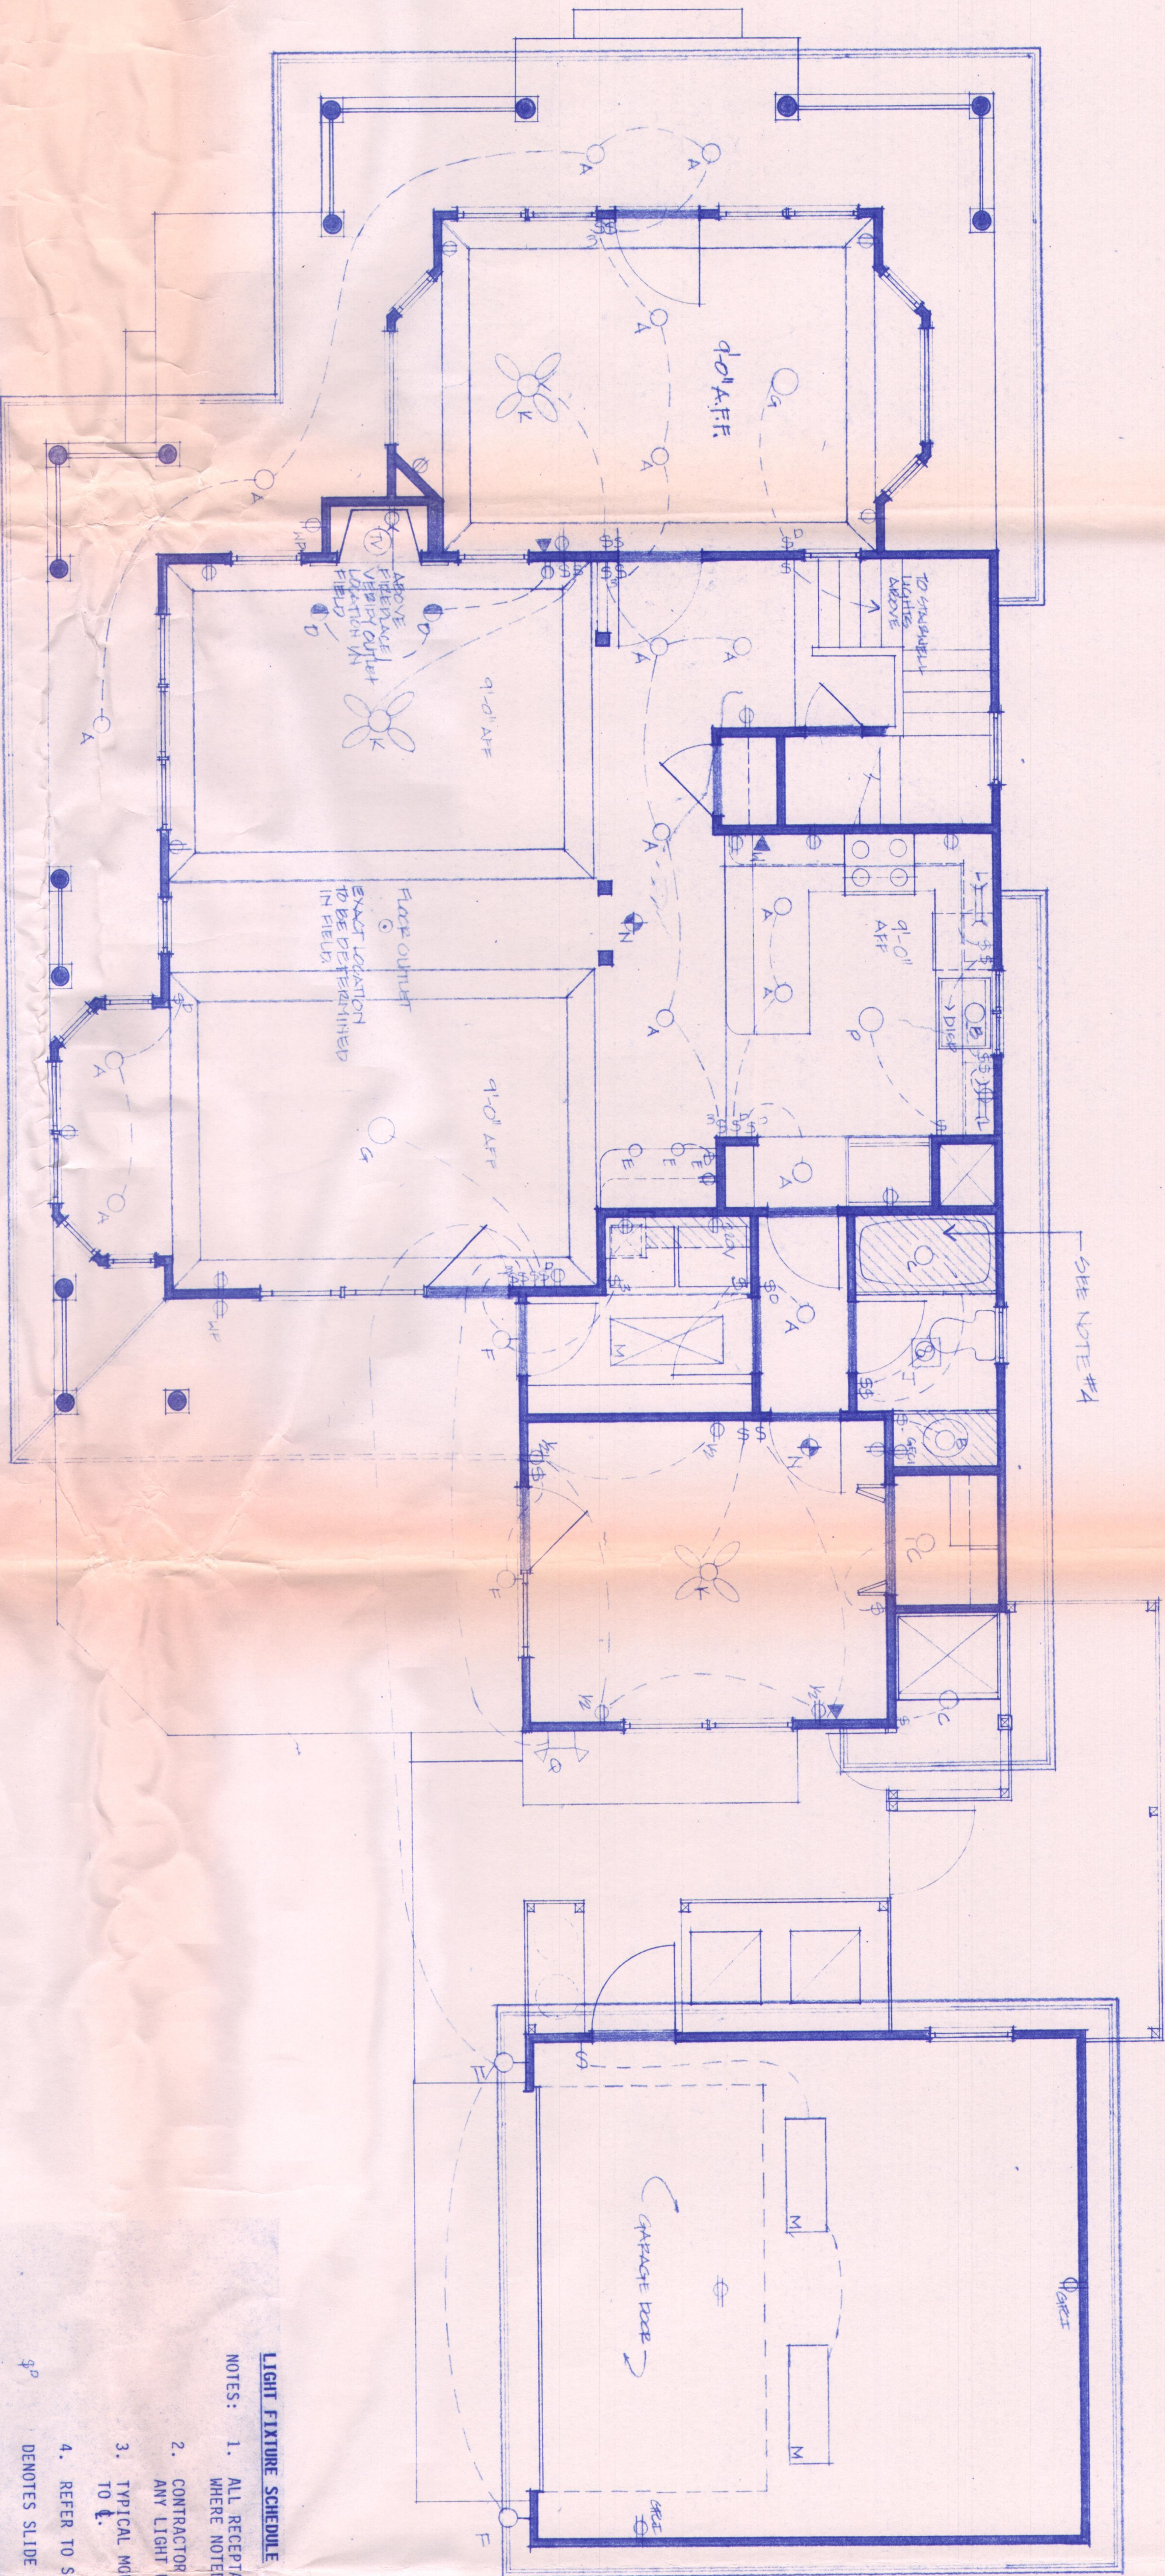

LIGHT FIXTURE SCHEDULE

NOTES:

1. ALL RECEPTACLES AND SWITCHES SHALL BE LEVITON DECORA, WHITE, EXCEPT WHERE NOTED OTHERWISE.
 2. CONTRACTOR SHALL OBTAIN ARCHITECT'S APPROVAL, PRIOR TO SUBSTITUTION OF ANY LIGHT FIXTURE SPECIFIED.
 3. TYPICAL MOUNTING HEIGHT FOR DUPLEX RECEPTACLES ALONG THE BASEBOARD 8" TO 8'.
 4. REFER TO SPECIFICATION SHEETS FOR ADDITIONAL INFORMATION.
- 9" DENOTES SLIDE TYPE DIMMER, "SKYLARK" BY LUTRON.
- A DENOTES RECESSED DOWNLIGHT W/BLACK COULEX BAFFLE & WHITE MINI-TRIM, HALO #410 W/H-T HOUSING, 75W R30. PROVIDE SLIDE TYPE DIMMER SWITCH "SKYLARK" BY LUTRON (TYPICAL) (ALTERNATE FOR INTERIOR USE ONLY - LIGHTTOLIER #1002P1/1005)
- B DENOTES RECESSED DOWNLIGHT WITH BLACK COULEX BAFFLE & WHITE MINI-TRIM, HALO #410 W/H-T HOUSING, 150W R40. PROVIDE SLIDE TYPE DIMMER SWITCH. (ALTERNATE - LIGHTTOLIER #1002P1/1105).
- C RECESSED SHOWER LIGHT W/DROP OPAL PLASTIC, HALO #71PS W/H-T HOUSING, 60W, A19 LAMP.
- D RECESSED WALL WASHER, HALO #425 W/H-T HOUSING, 60W A19 LAMP.
- E RECESSED SMALL DOWNLIGHT W/COULEX BAFFLE HALO #993 W/H-99T HOUSING, 40W R16 LAMP.
- F WALL MOUNTED CYLINDER HALO #H1313, 75W R30 LAMP, WHITE.
- G PENDANT FIXTURE TO BE SELECTED BY OWNER.
- H INCANDESCENT LAMP W/PORCELAIN SOCKET, 60W A19 LAMP. (IN ATTIC)
- J HEAT-VENT-LIGHT, NUTONE #9655N.
- K CEILING FAN TO BE SELECTED BY OWNER.
- L UNDERCABINET FLUORESCENT STRIP, 2'-0" LONG.
- M SURFACE MOUNTED FLUORESCENT FIXTURE, 1'-6" X 4'-0", W/ACRYLIC LENS, (4) 40W LAMPS.
- N AC DIRECT WIRE SMOKE DETECTOR, INTERCONNECTED, UL LABEL, W/BATTERY BACK-UP.
- P CEILING MOUNTED SQUARE OPAL GLASS FIXTURE, PROGRESS #P3529, 121" SQUARE, (2) 60W LAMPS, OR EQUAL.
- Q DOUBLE EXTENSION SPOTLIGHTS.
- R TELEPHONE JACK, WITH WALL PLATE, WHERE INDICATED, ("W" SUFFIX DENOTES WALLPHONE).
- S CABLE T.V. JACK, FLUSH WITH WALL.
- T FLOOR OUTLET - EXACT LOCATION TO BE DETERMINED IN FIELD.

NOTES:

1. PROVIDE ONE (1) SMOKE DETECTOR IN THE ATTIC.
2. TV OUTLETS TO BE LOCATED BY THE OWNER IN THE FIELD.
3. ALL CEILING HEIGHTS TO BE 8'-0", EXCEPT WHERE NOTED OTHERWISE.
4. SHADED AREAS REPRESENTED DROPPED SOFFITS AT 7'-11" TO ROUGH.

1 REFLECTED CEILING/ELECTRICAL PLAN - FIRST FLOOR
SCALE: 1/8" = 1'-0"