



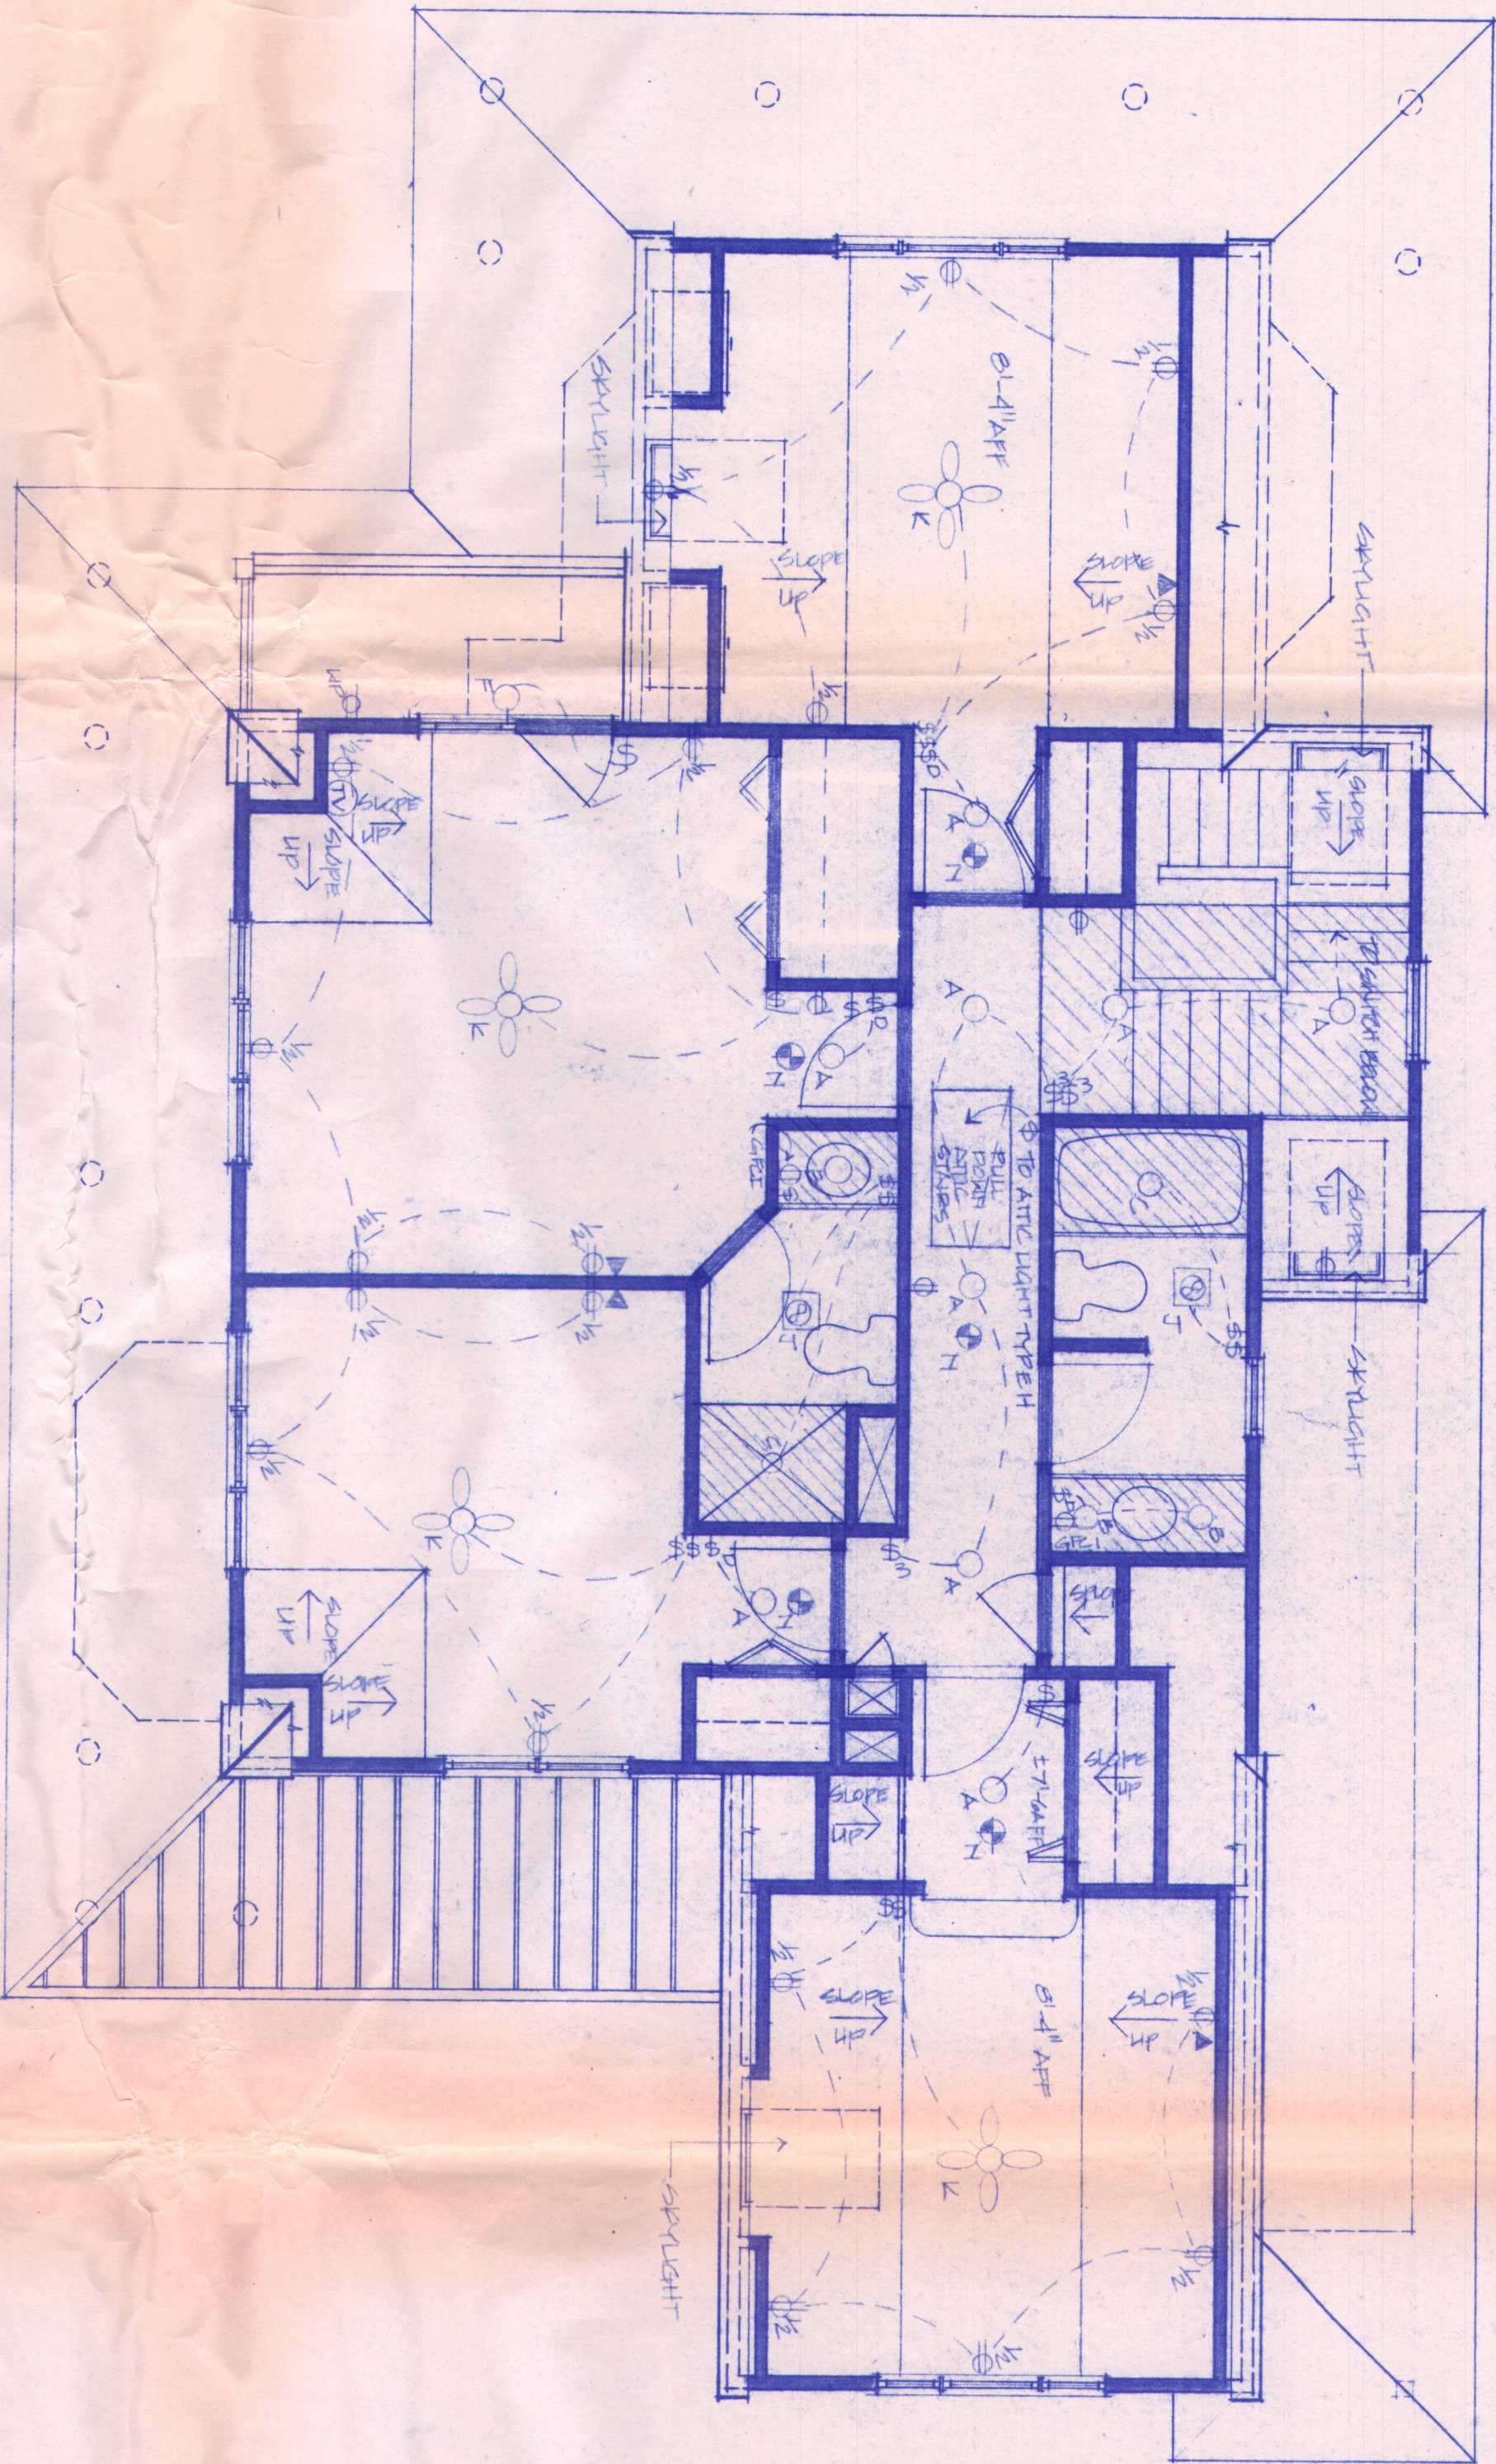

NOTES:
1. PROVIDE (1) SMOKE DETECTOR IN ATTIC
2. TV OUTLETS TO BE LOCATED BY OWNER IN FIELDS

1 REFLECTED CEILING/ELECTRICAL PLAN
A10 SCALE: 1/4" = 1'-0"

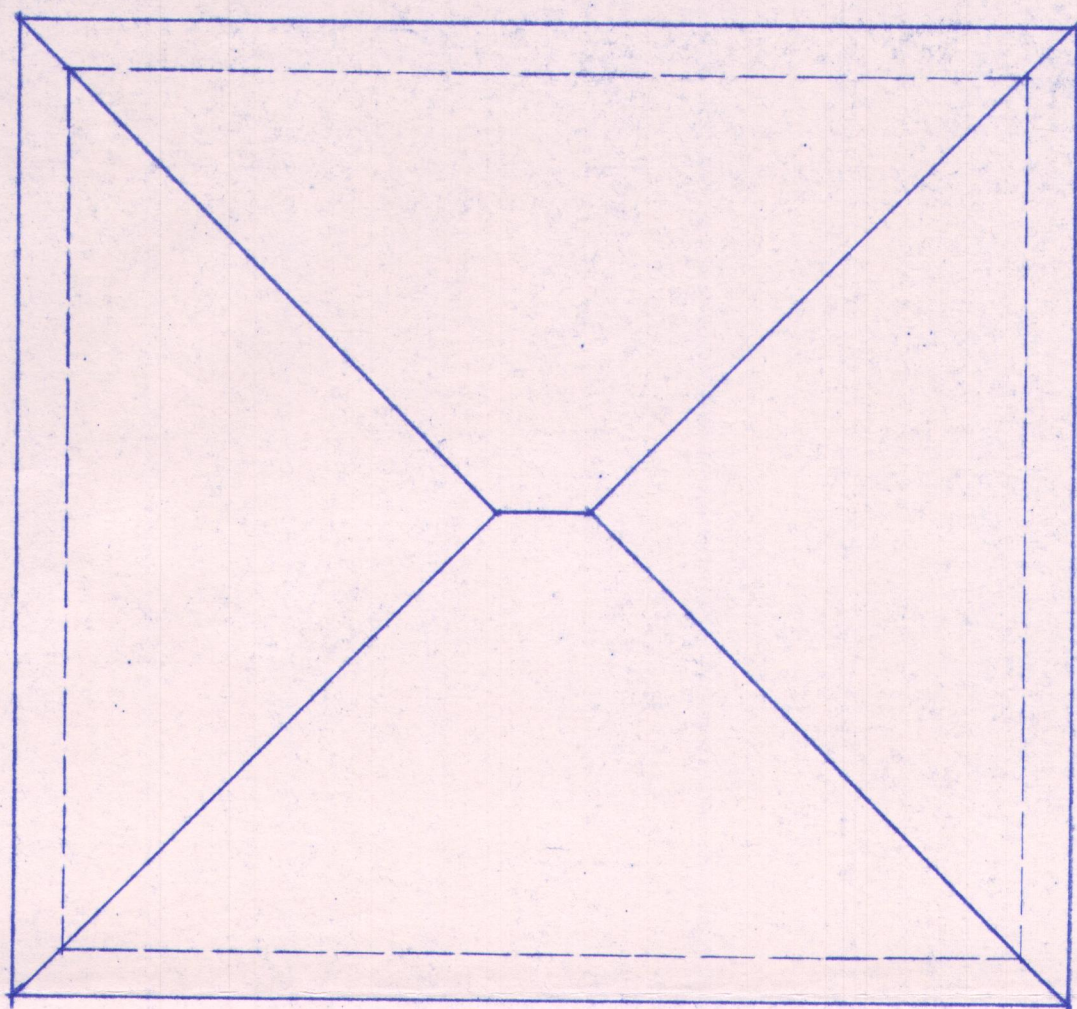

601 CHEROKEE ROAD
PO BOX 4840
PINEHURST NC 28374
919 895 4800
FAX 919 295 4862

DATE

DATE 2 March 1994

TEGISTIA CHAO, AIA

REVISIONS

REVISION SET

DATE	2/2/94
BY	TEGISTIA
CHK	TEGISTIA
APP	TEGISTIA

NEW RESIDENCE FOR
MR. MICHAEL BEVILACQUA
LOT #10, BLOCK 20, 5 JERSEY CITY AVE.
LAVALLETTE, NT 08735

REFLECTED CEILING
ELECTRICAL PLAN

SECOND FLOOR

DATE 2/2/94

BY TEB

JOB #1002

A10