

YANKEE CANDLE

STORE #456
THE SHOPPES AT NORTH
BRUNSWICK
RT. 01 - Rt. 130
SPACE #07
NORTH BRUNSWICK, NJ 08902

NORTH BRUNSWICK TOWNSHIP
CONSTRUCTION DIVISION
PLAN REVIEW


BUILDING SUB-CODE _____
PLUMBING SUB-CODE _____
ELECTRICAL SUB-CODE _____
FIRE SUB-CODE 44452 10-11-02
CONSTRUCTION OFFICIAL _____

FIRE ALARM GENERAL NOTES:

1. FIRE ALARM SYSTEM DESIGN, INSTALLATION AND MATERIALS SHALL BE IN ACCORDANCE WITH NFPA 70 AND NFPA 72. SYSTEM SHALL ALSO MEET ALL APPLICABLE BUILDING CODES, FIRE CODES AND THE REQUIREMENTS OF THE AUTHORITY HAVING JURISDICTION AND INSURANCE CARRIER. VERIFY REQUIREMENTS PRIOR TO BID SUBMITTAL.
2. INFORMATION ON CONTRACT DOCUMENTS IS GENERAL INFORMATION AND FOR BID PURPOSES ONLY. LAYOUT SYSTEM, PERFORM REQUIRED CALCULATIONS AND COORDINATE WITH OTHER TRADES.
3. PROVIDE ADDITIONAL MATERIALS AND LABOR REQUIRED DUE TO LACK OF COORDINATION OR TO MEET AUTHORITY HAVING JURISDICTION AND INSURANCE CARRIER REQUIREMENTS AT NO ADDITIONAL COST TO THE OWNER.
4. PROVIDE ALL EQUIPMENT AND LABOR REQUIRED FOR A COMPLETE AND OPERATIONAL FIRE ALARM SYSTEM.
5. PROVIDE AUDIBLE AND VISIBLE NOTIFICATION APPLIANCES AS INDICATED ON THE DRAWINGS. ALL VISIBLE NOTIFICATION APPLIANCES CANDELA SHALL BE AS SHOWN ON DRAWINGS UNLESS NOTED OTHERWISE.
6. PROVIDE DUCT DETECTION AND SHUTDOWN FOR AIR DISTRIBUTION SYSTEMS EXCEEDING 2000 CFM. DUCT SMOKE DETECTION SHALL TRANSMIT A SUPERVISORY SIGNAL TO THE FACP.
7. FORWARD COMPLETED FIRE ALARM CERTIFICATE OF COMPLETION TO THE OWNER.
8. REFER TO SPECIFICATIONS FOR ADDITIONAL INFORMATION.

FIRE ALARM PLAN NOTES:

- ① PROVIDE DUCT MOUNTED SMOKE DETECTOR FOR AIR HANDLING UNIT SHUT-DOWN. INSTALL DETECTOR PER MANUFACTURER'S RECOMMENDATIONS. REFER TO MECHANICAL SHEETS FOR AIR HANDLING UNIT AND DUCTWORK LAYOUT AND DETAILS.
- ② PROVIDE JUNCTION BOX FOR CONNECTION TO THE EXISTING FIRE ALARM CONTROL PANEL.
- ③ CONNECT FIRE SPRINKLER MONITORING DEVICES TO FIRE ALARM SYSTEM. COORDINATE QUANTITY AND LOCATION OF DEVICES WITH FIRE PROTECTION SYSTEMS.

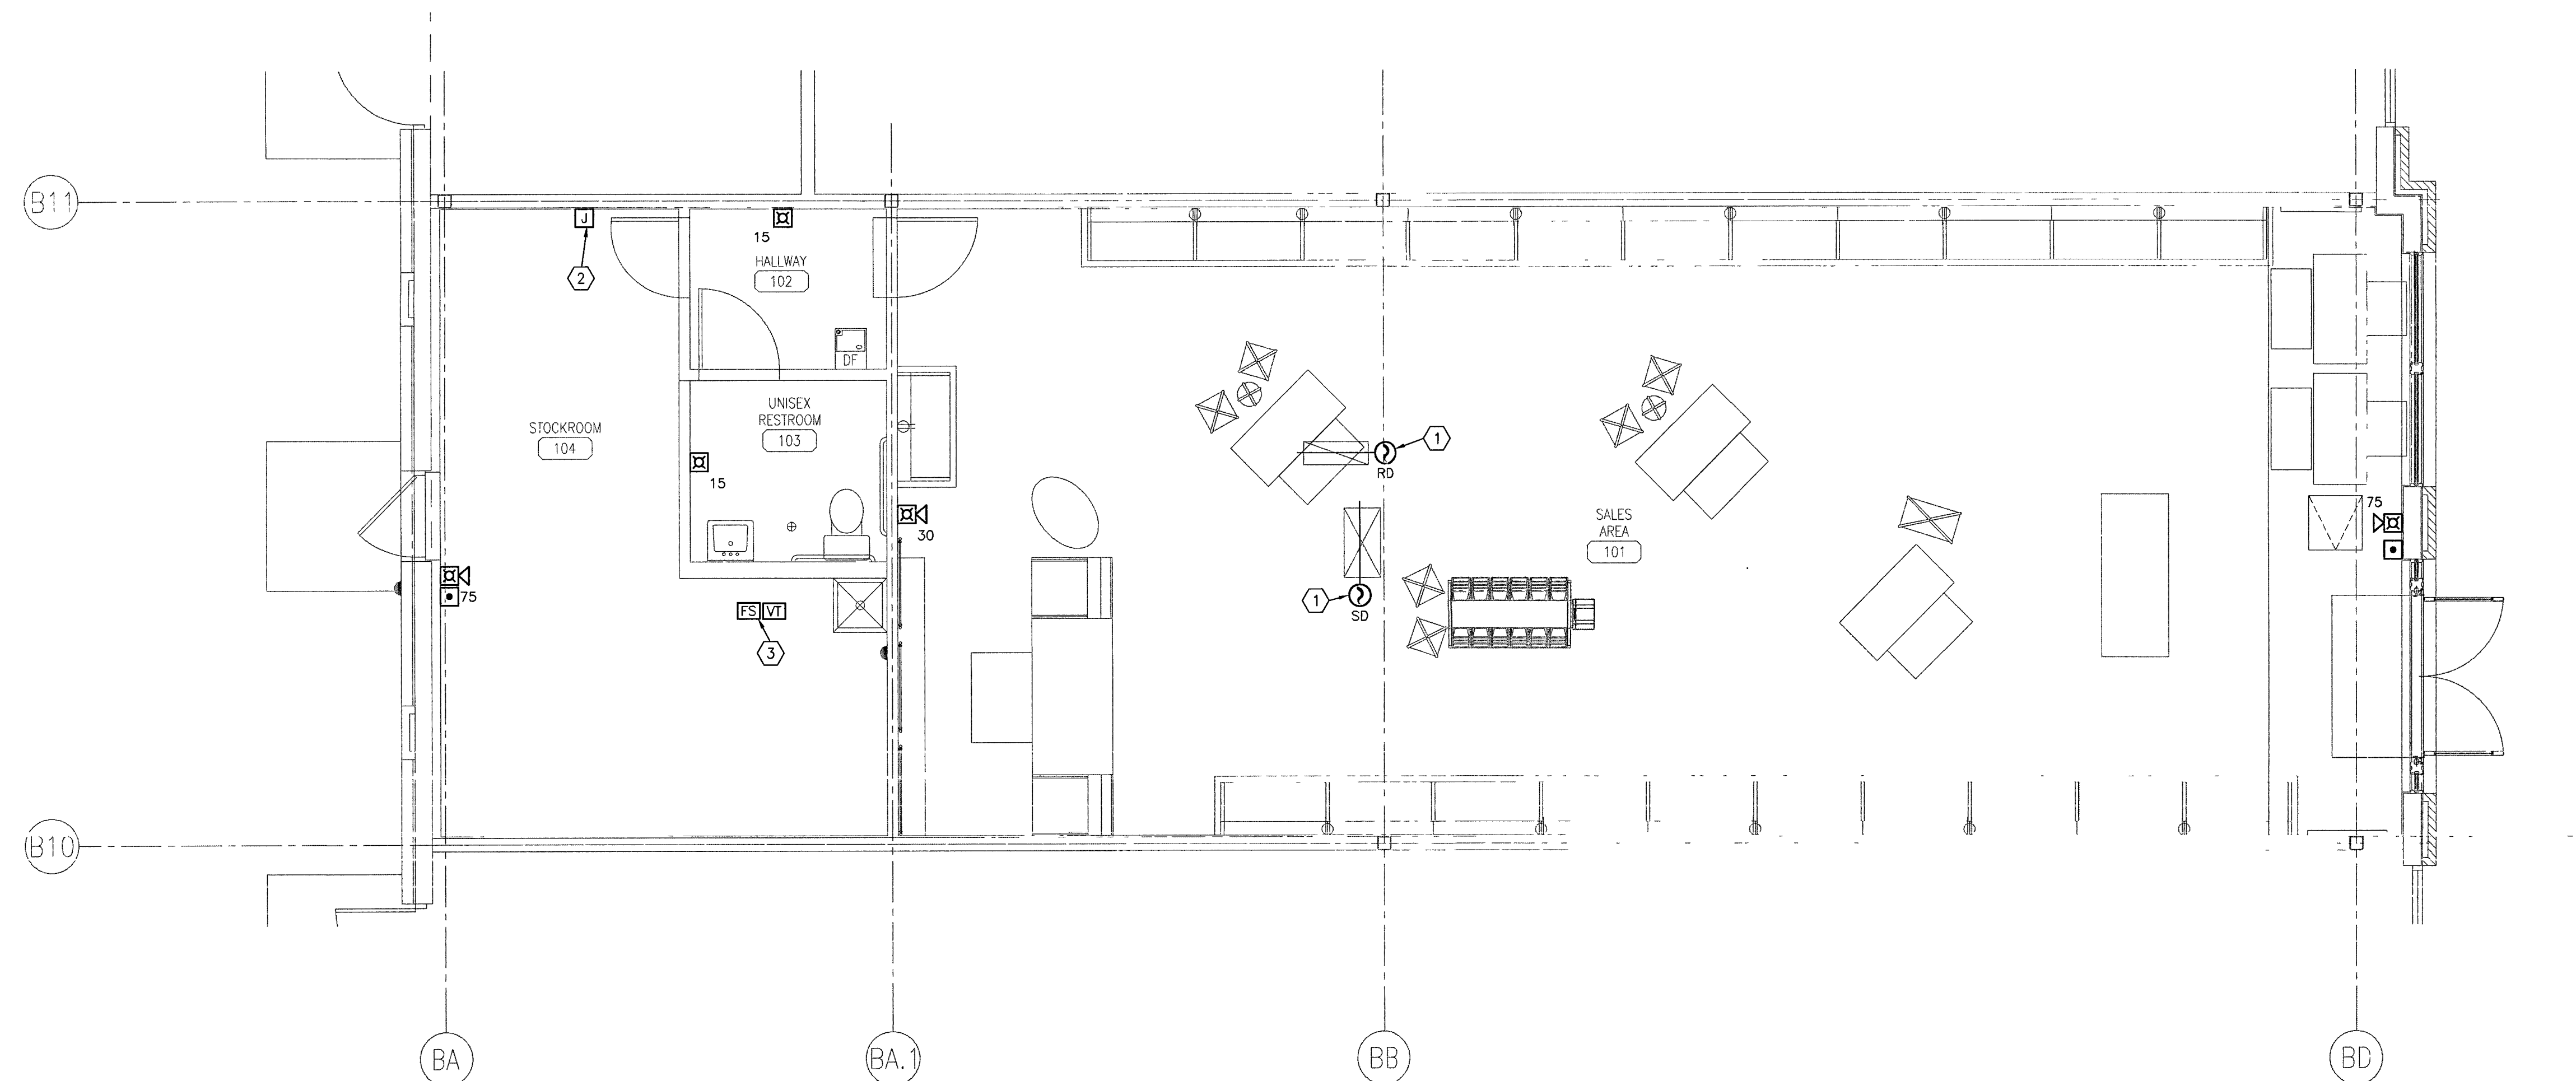

8325 LENEXA DRIVE
LENEXA, KS 66214
TEL 913 742 5000 FAX 913 742 5001
www.hel-eng.com
0750001411
NL CORPORATE NUMBER: 24627943400
08/31/08

design-forum
architects

7575 Paragon Road, Dayton, Ohio 45459 Telephone: (937) 439-4400

Drawing Title
**FIRE ALARM
FLOOR PLAN**

Seal	Drawn MAM	Project No. 711706.00
	Checked DES	Scale AS NOTED
	Date 09/21/2007	Drawing No. F-111

© 2007 DESIGN FORUM ARCHITECTS

F1 FIRE ALARM - FLOOR PLAN

1/4" = 1'-0"

LDS NOB-B 10702398