

NOTE: A CAMPBELL FOUNDATION PATTERN #1502 TYPE A, BOLTED, WATERTIGHT MANHOLE COVER SHALL BE INSTALLED IN PLACE OF THE SEPTIC TANK LID AND SHALL BE INSTALLED AT FINISHED GRADE. PROVIDE BITUMINOUS SEAL WHERE CASTING MEETS TOP OF SEPTIC TANK OR PRECAST RISER.

IT IS HEREBY CERTIFIED THAT THERE ARE NO COMPONENTS OF THE PROPOSED SEPTIC SYSTEM WITHIN 100' TO ANY PROPOSED OR EXISTING WELL. ALSO, THERE ARE NO EXISTING WELLS WITHIN 100' OF THE PROPOSED WELL. THERE ARE NO EXISTING DISPOSAL FIELDS WITHIN 50' OF THE PROPOSED DISPOSAL BED.

NOTE: "SELECT FILL" MEANS THE FOLLOWING COMPOSITION:

- A - COARSE FRAGMENT CONTENT LESS THAN 15% BY VOLUME OR LESS THAN 25% BY WEIGHT;
- B - TEXTURAL ANALYSIS (COMPOSITION, BY WEIGHT OF SIZE FRACTION PASSING THE 2 MILLIMETER SIEVE); FROM 85 TO 95% SAND, FROM 5 TO 15% SILT PLUS CLAY, MINIMUM 2% CLAY;
- C - PERMEABILITY FROM 2 TO 20 INCHES PER HOUR; OR PERCOLATION RATE FROM 3 TO 30 MINUTES PER INCH.

APPROVED

WASHINGTON TOWNSHIP
HEALTH DEPARTMENT

BY [Signature] DATE 6/1/93



ENGINEER MUST STAKE
DISPOSAL BED
BEFORE EXCAVATION

CALL FOR EXCAVATION
INSPECTION

SELECT FILL
INSPECTION REQUESTED

SEPTIC TANK
MUST BE
PUMPED EVERY
2-3 YEARS
TO PREVENT
SYSTEM
MALFUNCTION

NOTE:
REFER TO
SHEET 2 FOR
PROPOSED DRIVE
GRADING.

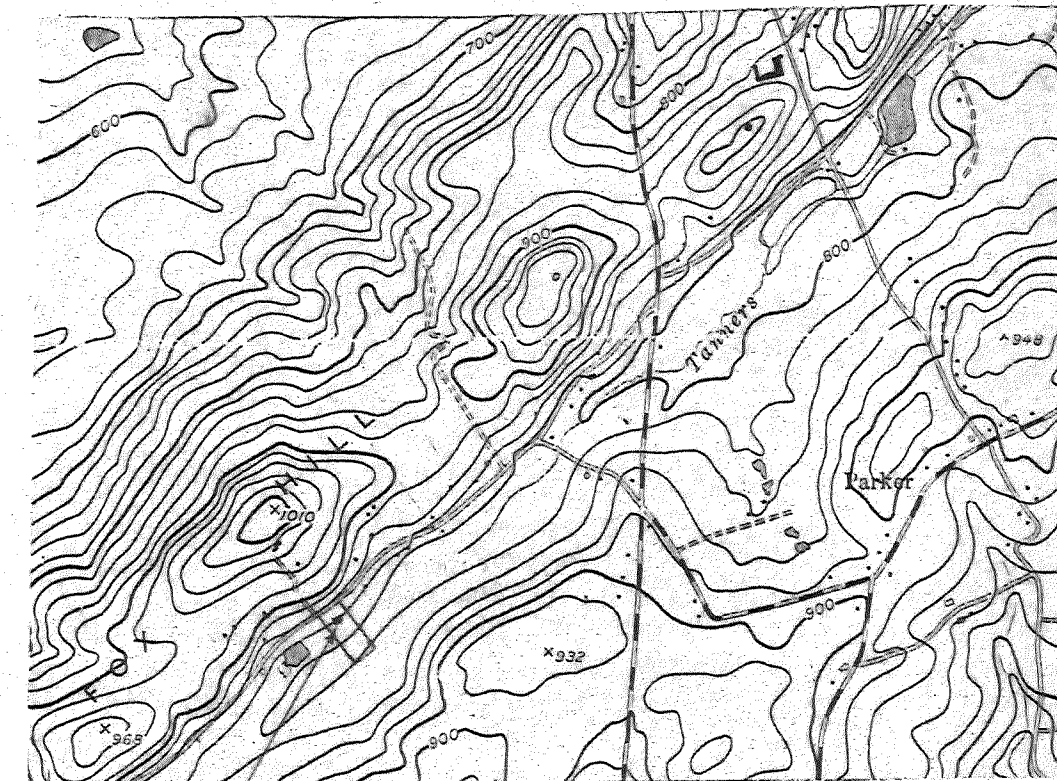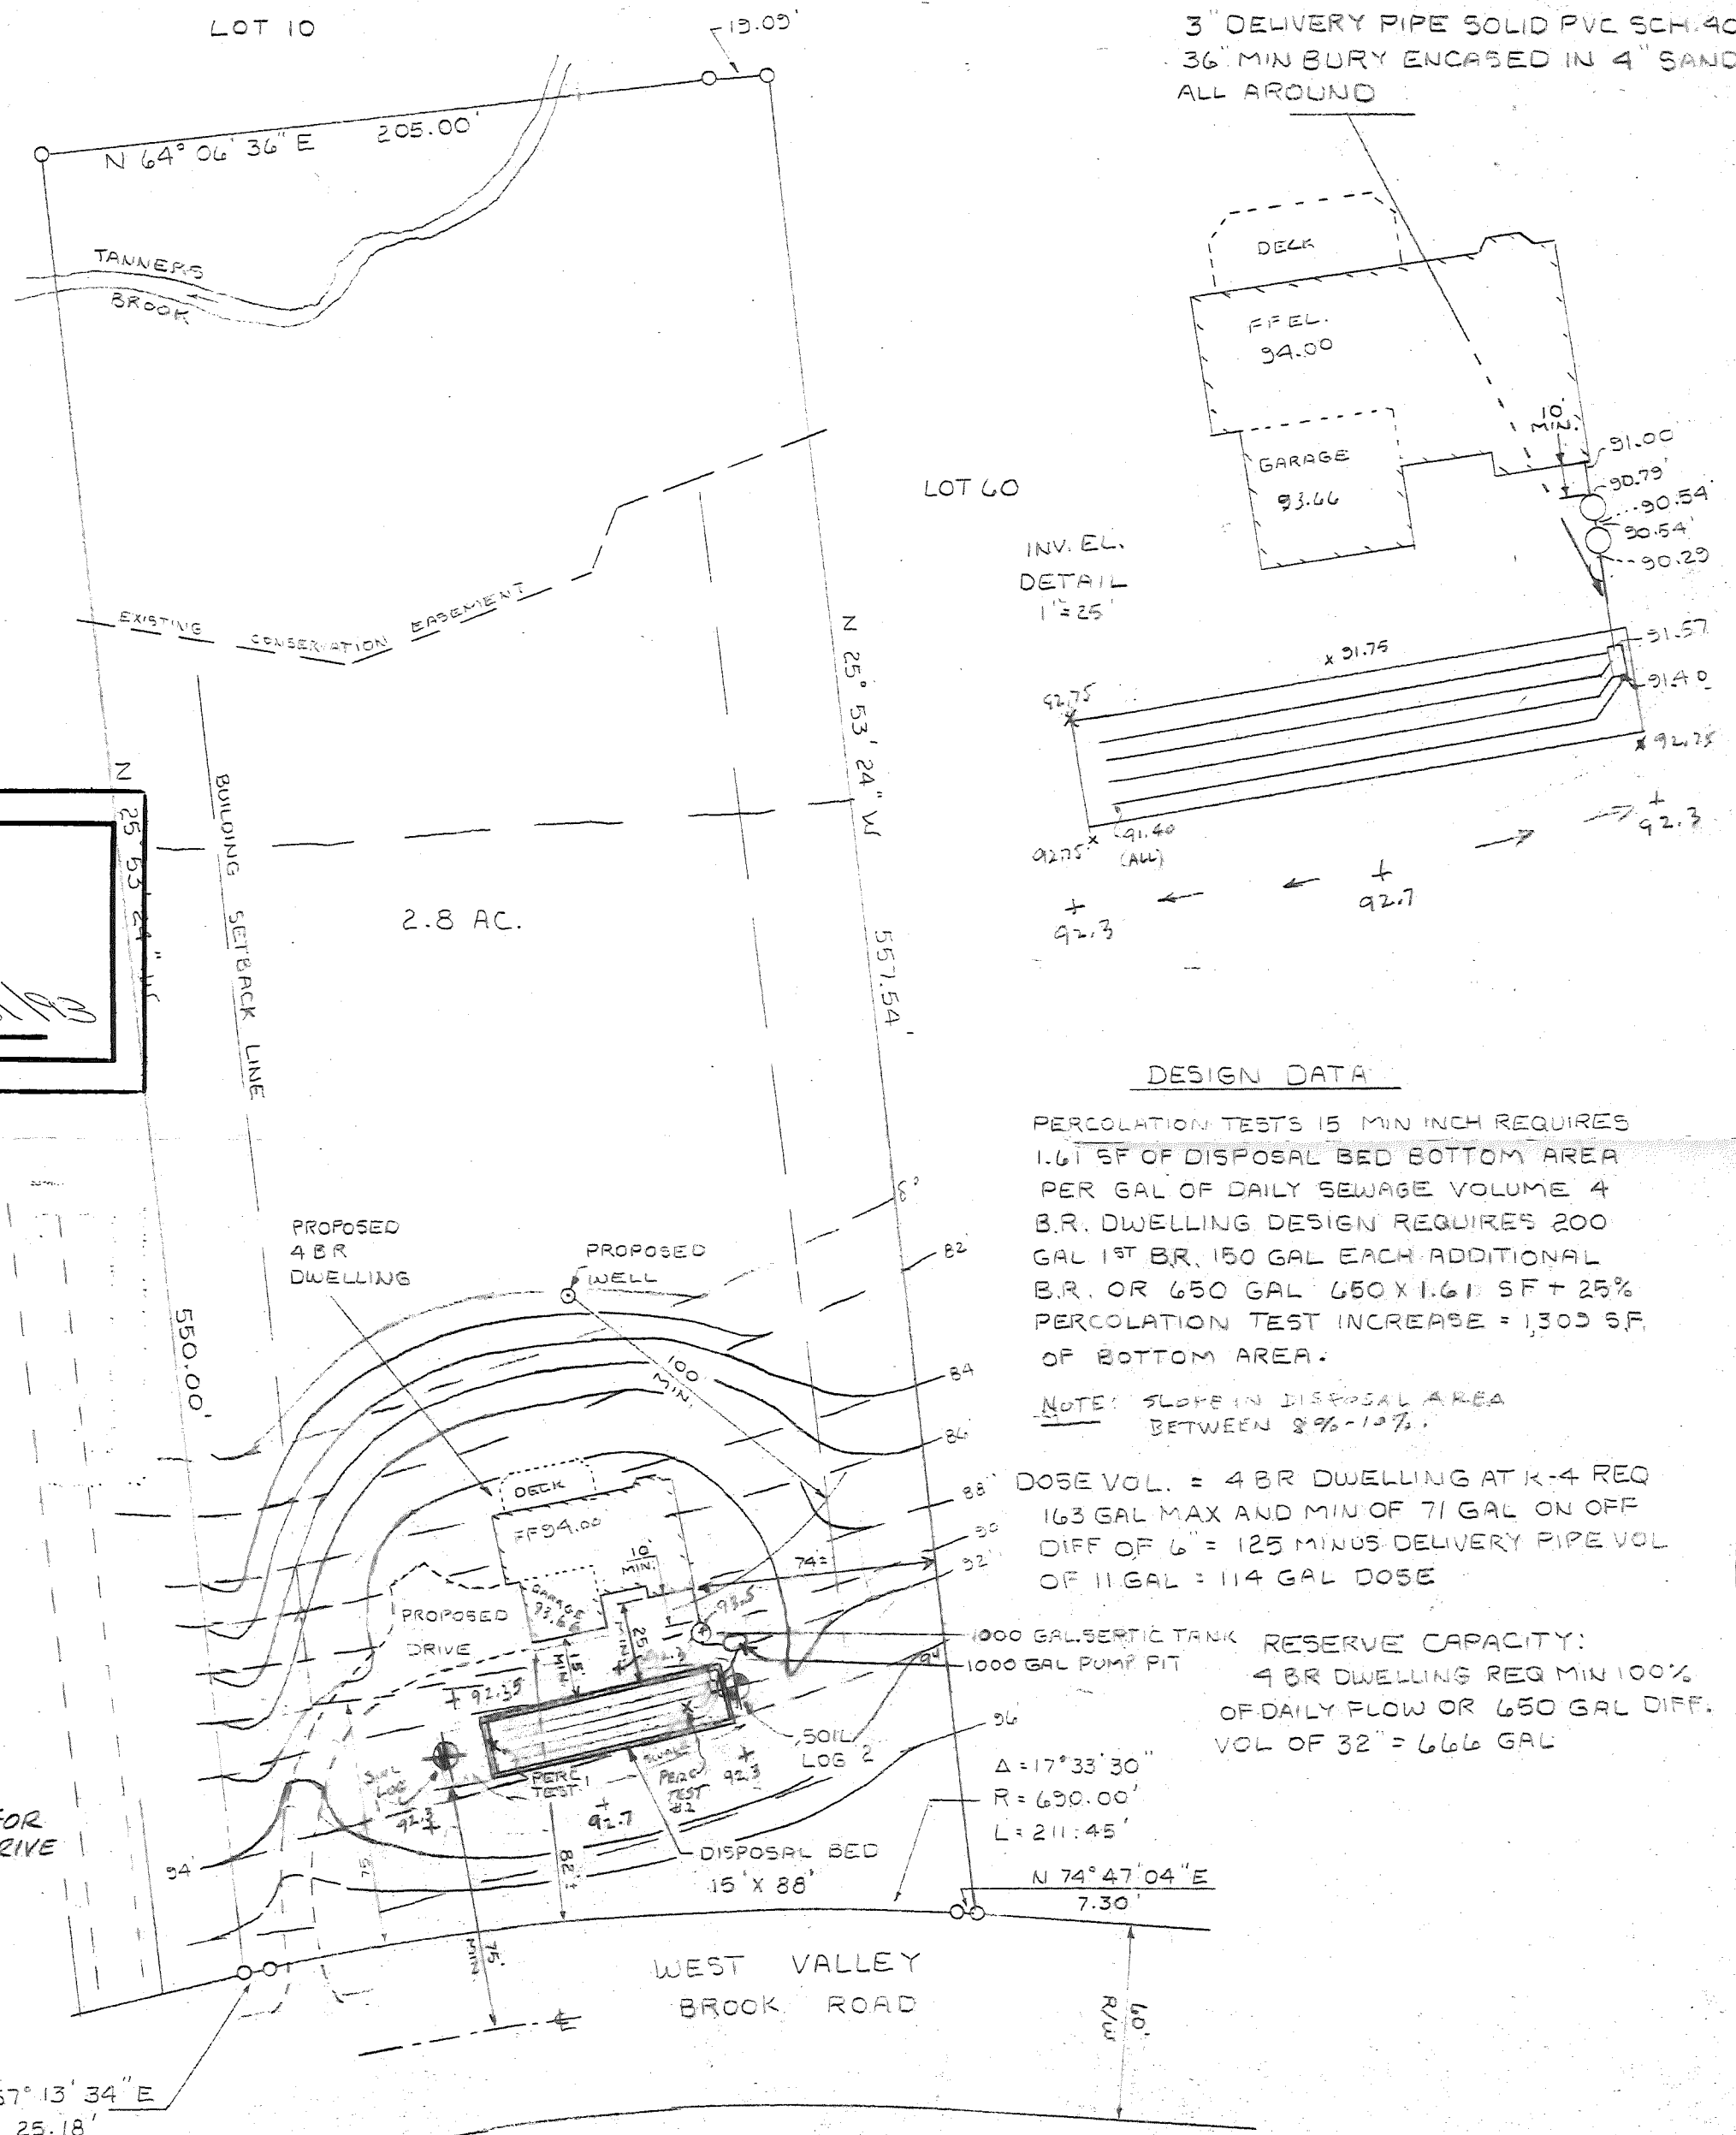

SITE PLAN
SEWAGE DISPOSAL SYSTEM
LOT 60.05 - BLOCK 50
WASHINGTON TOWNSHIP - MORRIS COUNTY
NEW JERSEY

CARLTON N. FROST *Carlton N. Frost*

Professional Engineer & Land Surveyor • N. J. Lic. No. 12672
Professional Planner • N. J. Lic. No. 1875

**ASSOCIATED
CONSULTANTS**

ENGINEERS AND LAND SURVEYORS INC.
PROFESSIONAL PLANNERS

530 East Main Street
P.O. Box 383
CHESTER, NEW JERSEY 07930-0383

SCALE: 1"=50'
DATE: 4-16-90
DESIGNED BY: CNF
DRAWN BY: JKF
BOOK:
FILE: 1808

3	6-8-93	APPROVED PUMP TANK
2	9-10-90	ADDED 2' ALL AROUND BED.
1	6-8-90	ADDED NOTE ON SLOPE, GRADING AT BED. NEW FIRE DATA CHANGED GRADING AND INVERTS.
NO.	DATE REVISION	DESCRIPTION

WASHINGTON TOWNSHIP
JUN 10 1993
REC'D HEALTH DEPT.