




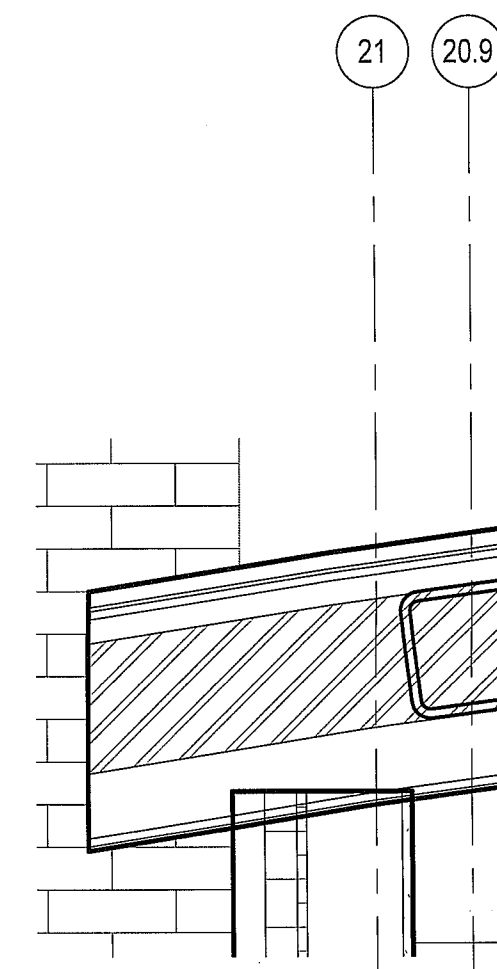


D1 Callout of Section 29
SCALE: 1" = 1'-0"

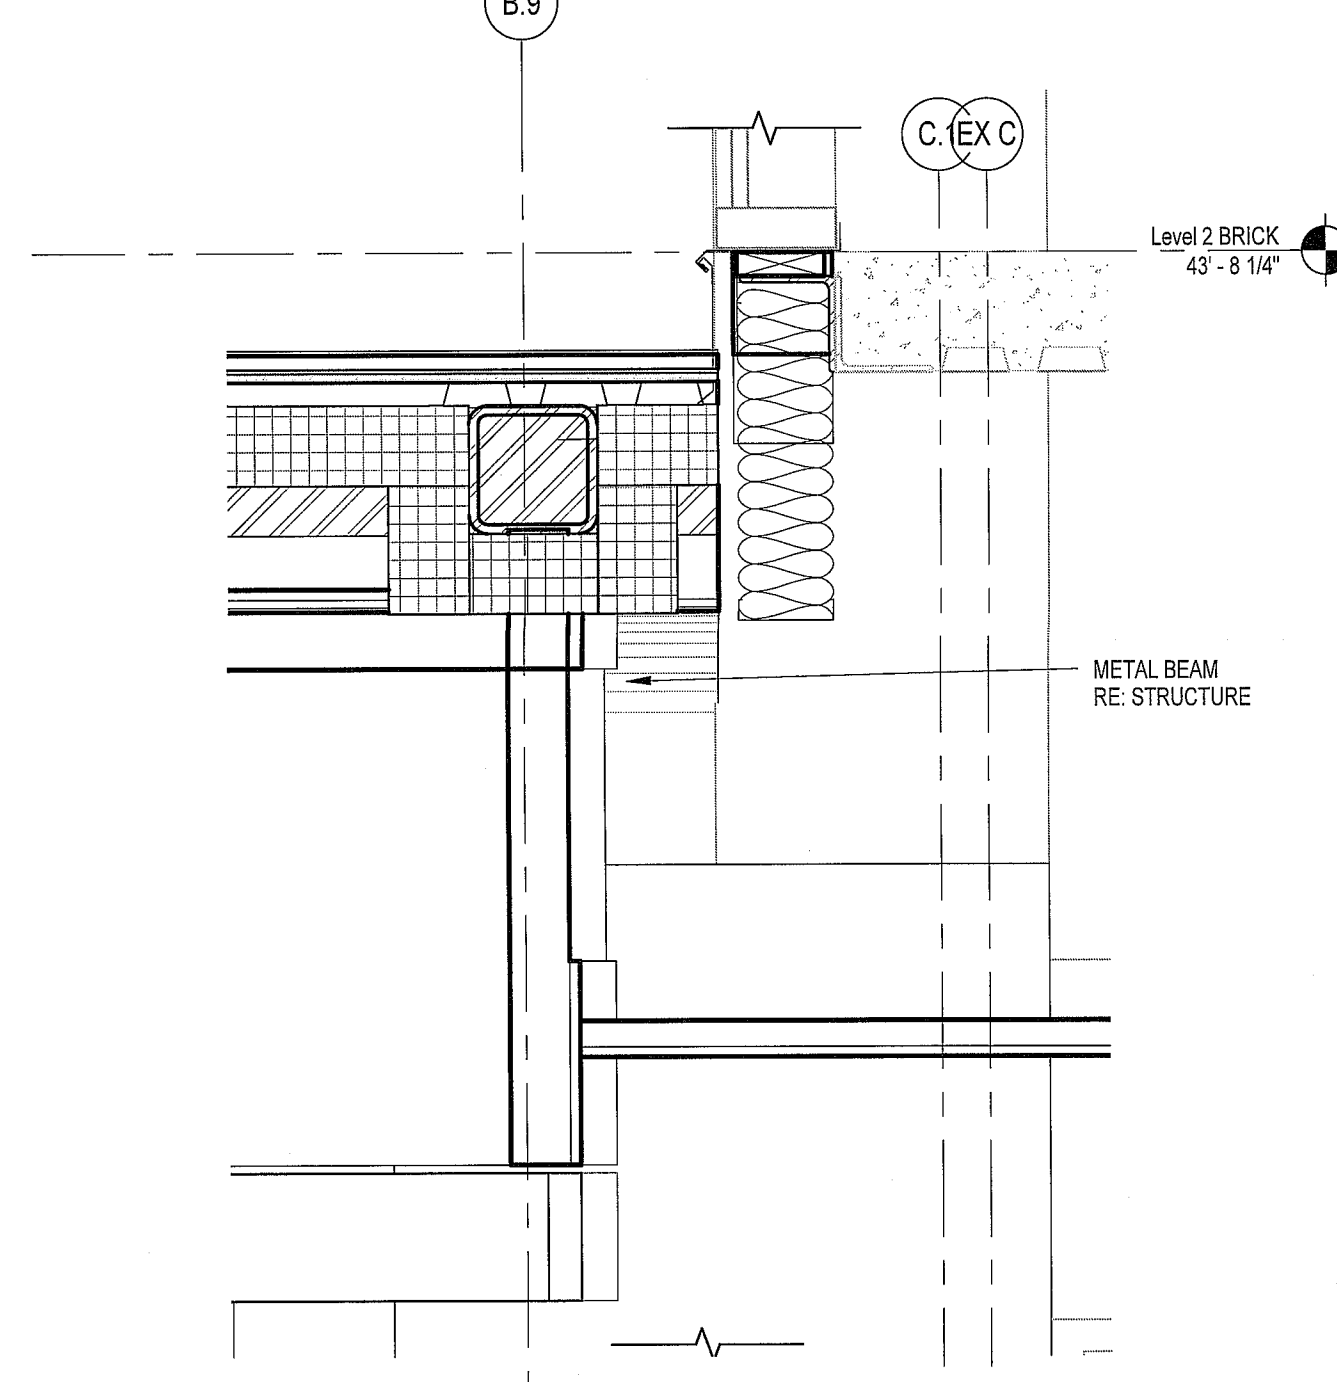


D2 CANOPY SECTION - FLASHING
SCALE: 1" = 1'-0"

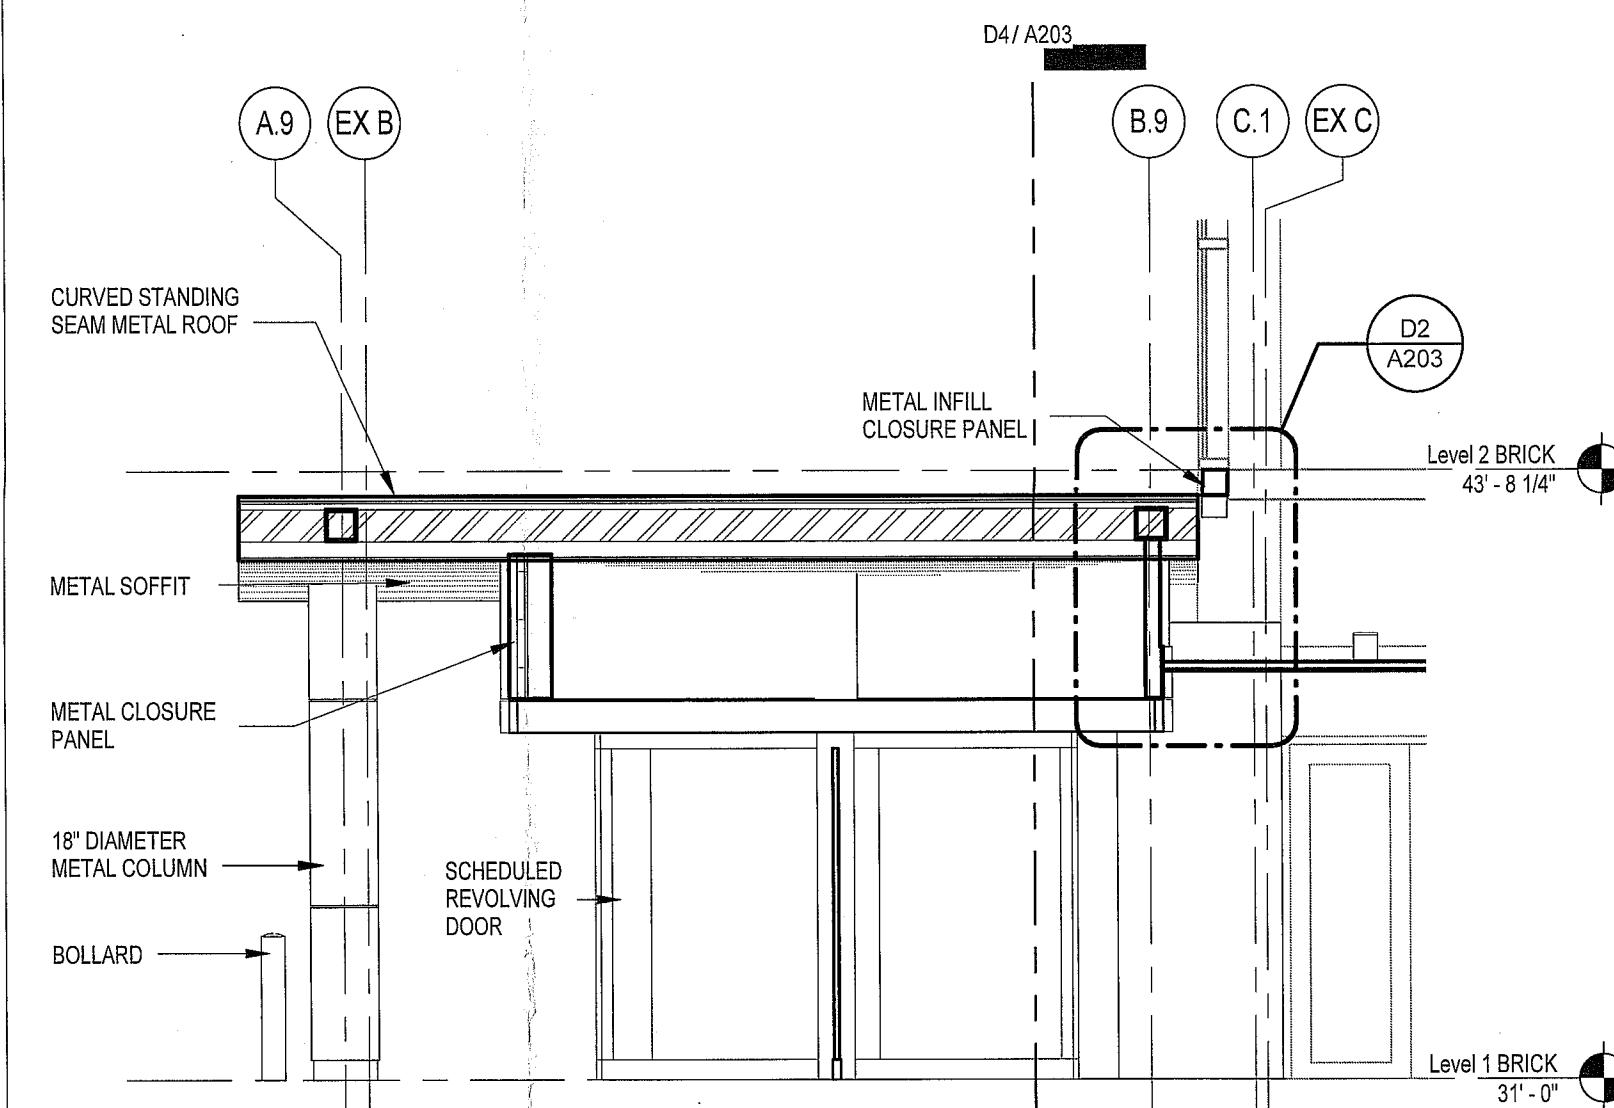


D3 CANOPY SECTION, EAST/WEST
SCALE: 1/4" = 1'-0"

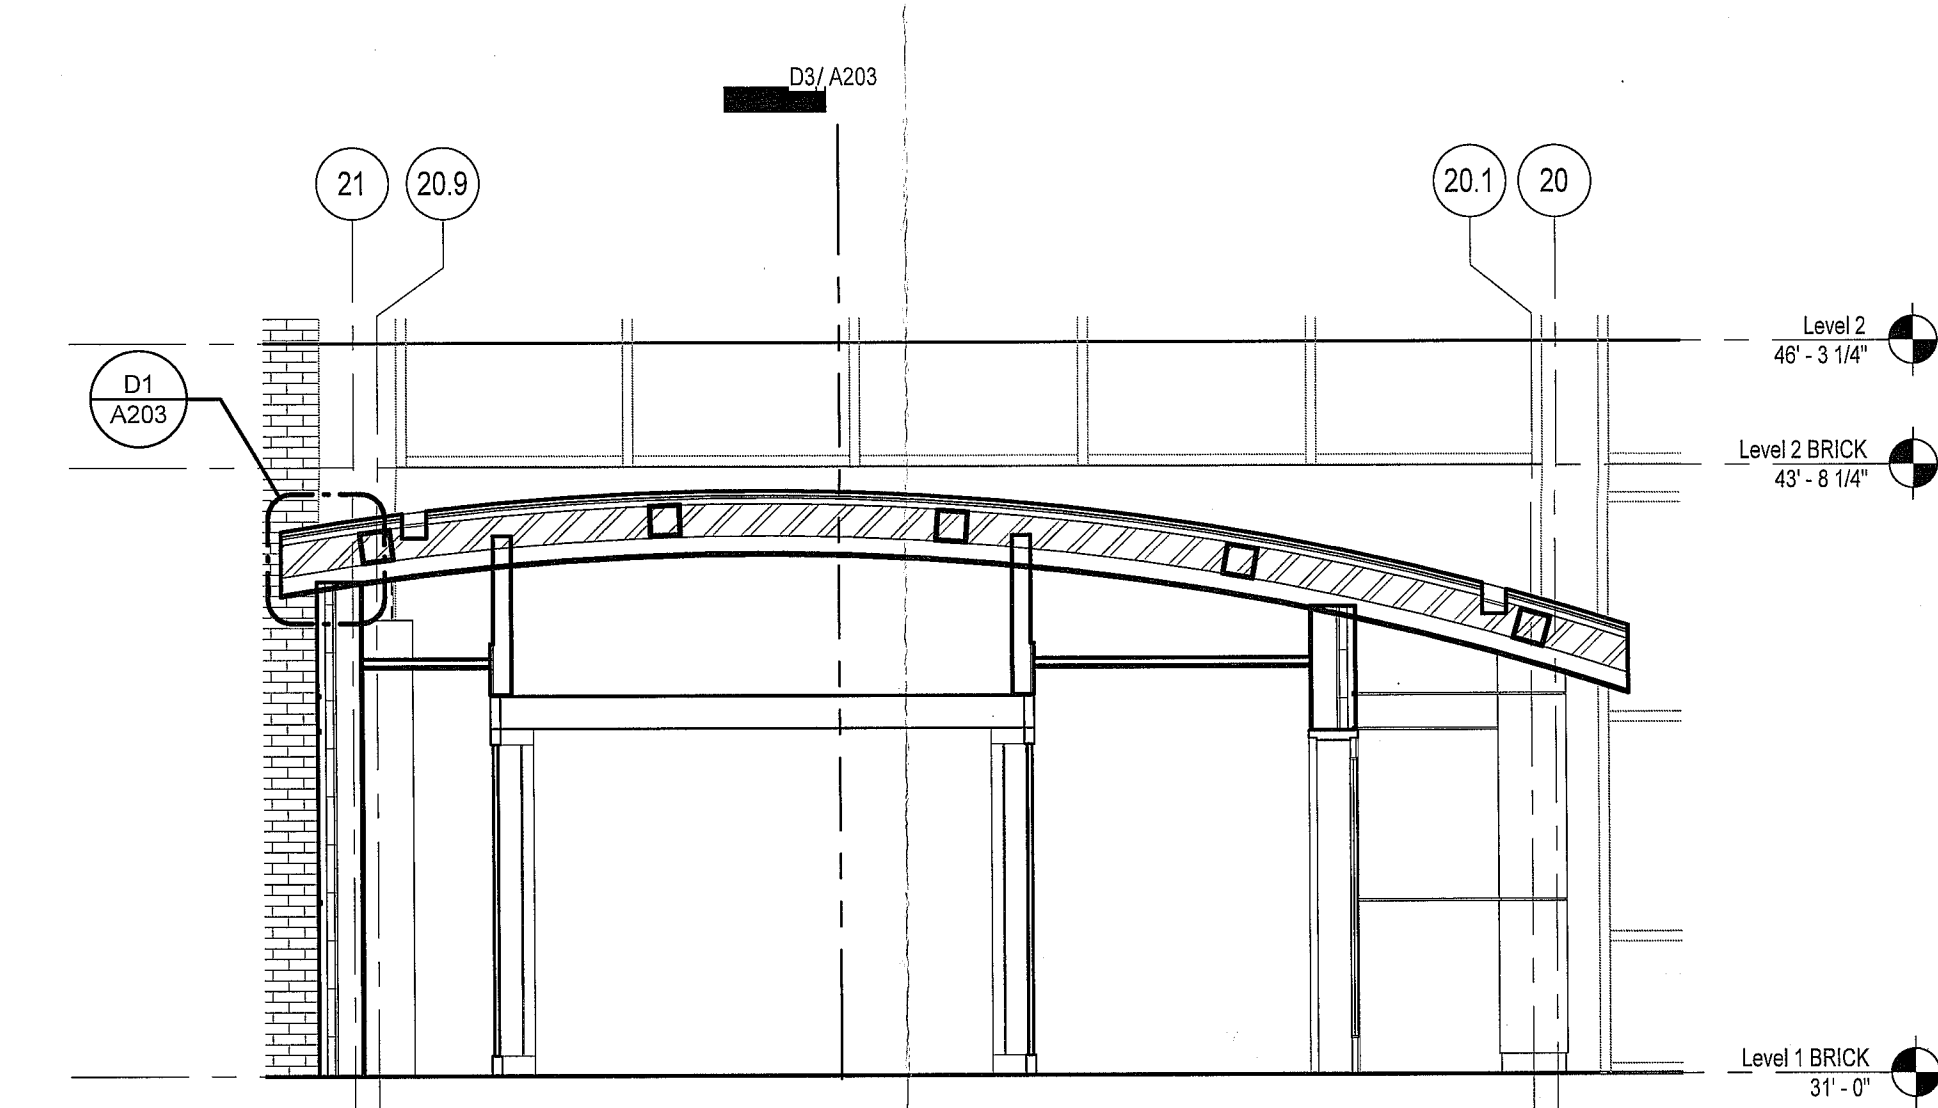


D4 CANOPY SECTION, NORTH/SOUTH
SCALE: 1/4" = 1'-0"

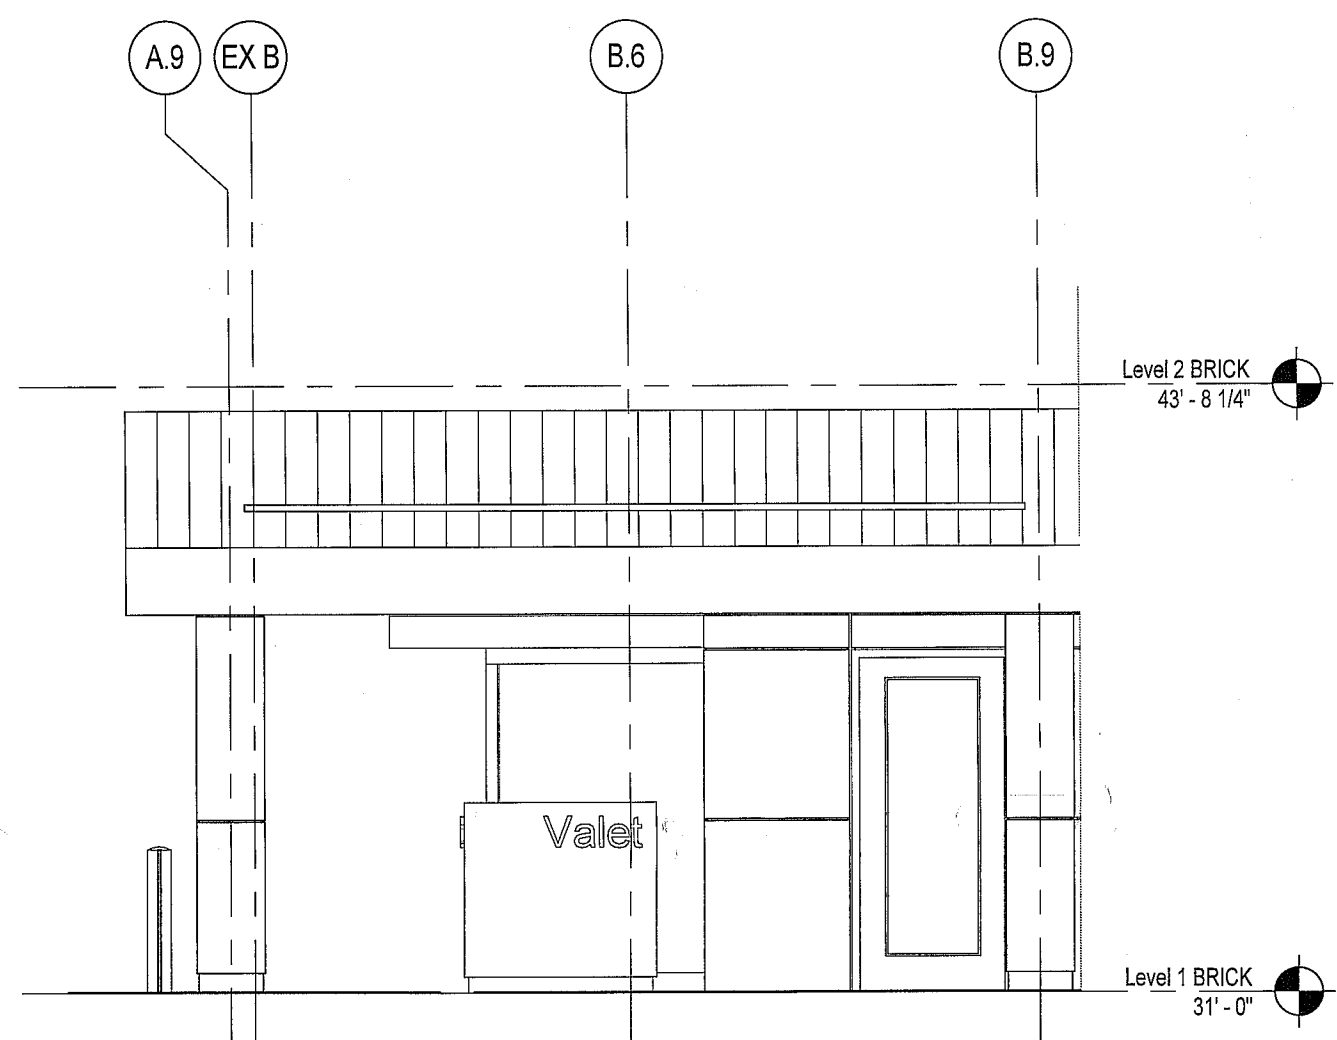


C2 CANOPY SOUTH ELEVATION
SCALE: 1/4" = 1'-0"

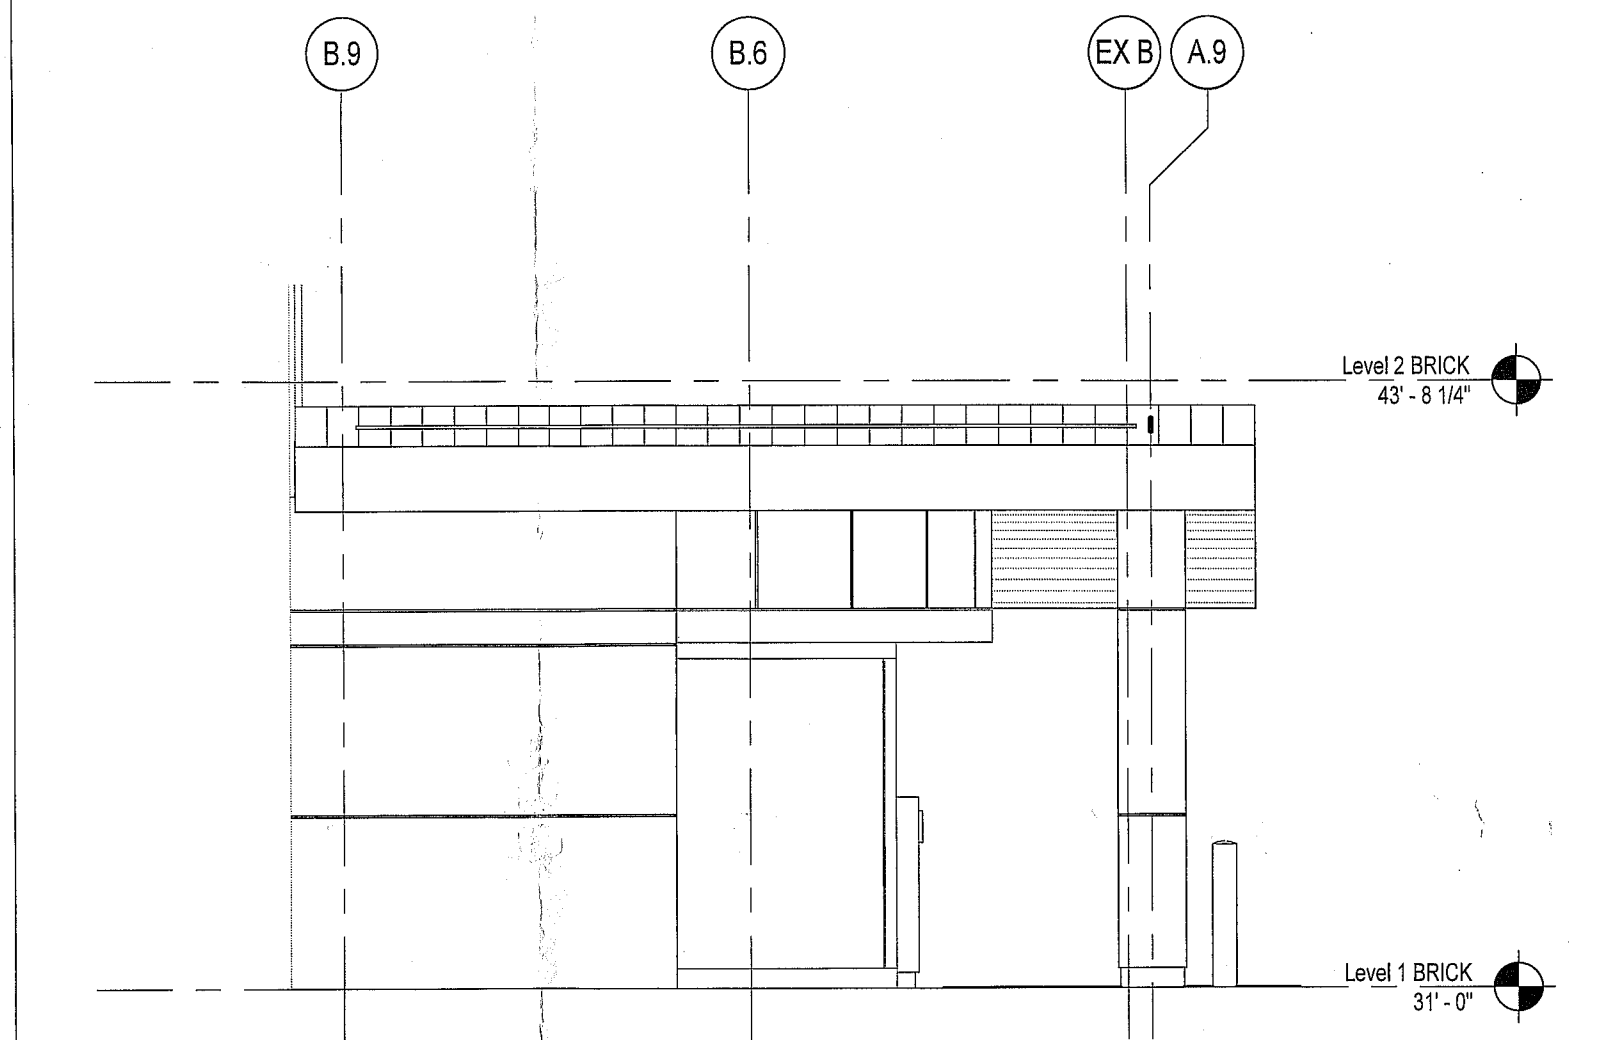


C3 CANOPY NORTH ELEVATION
SCALE: 1/4" = 1'-0"

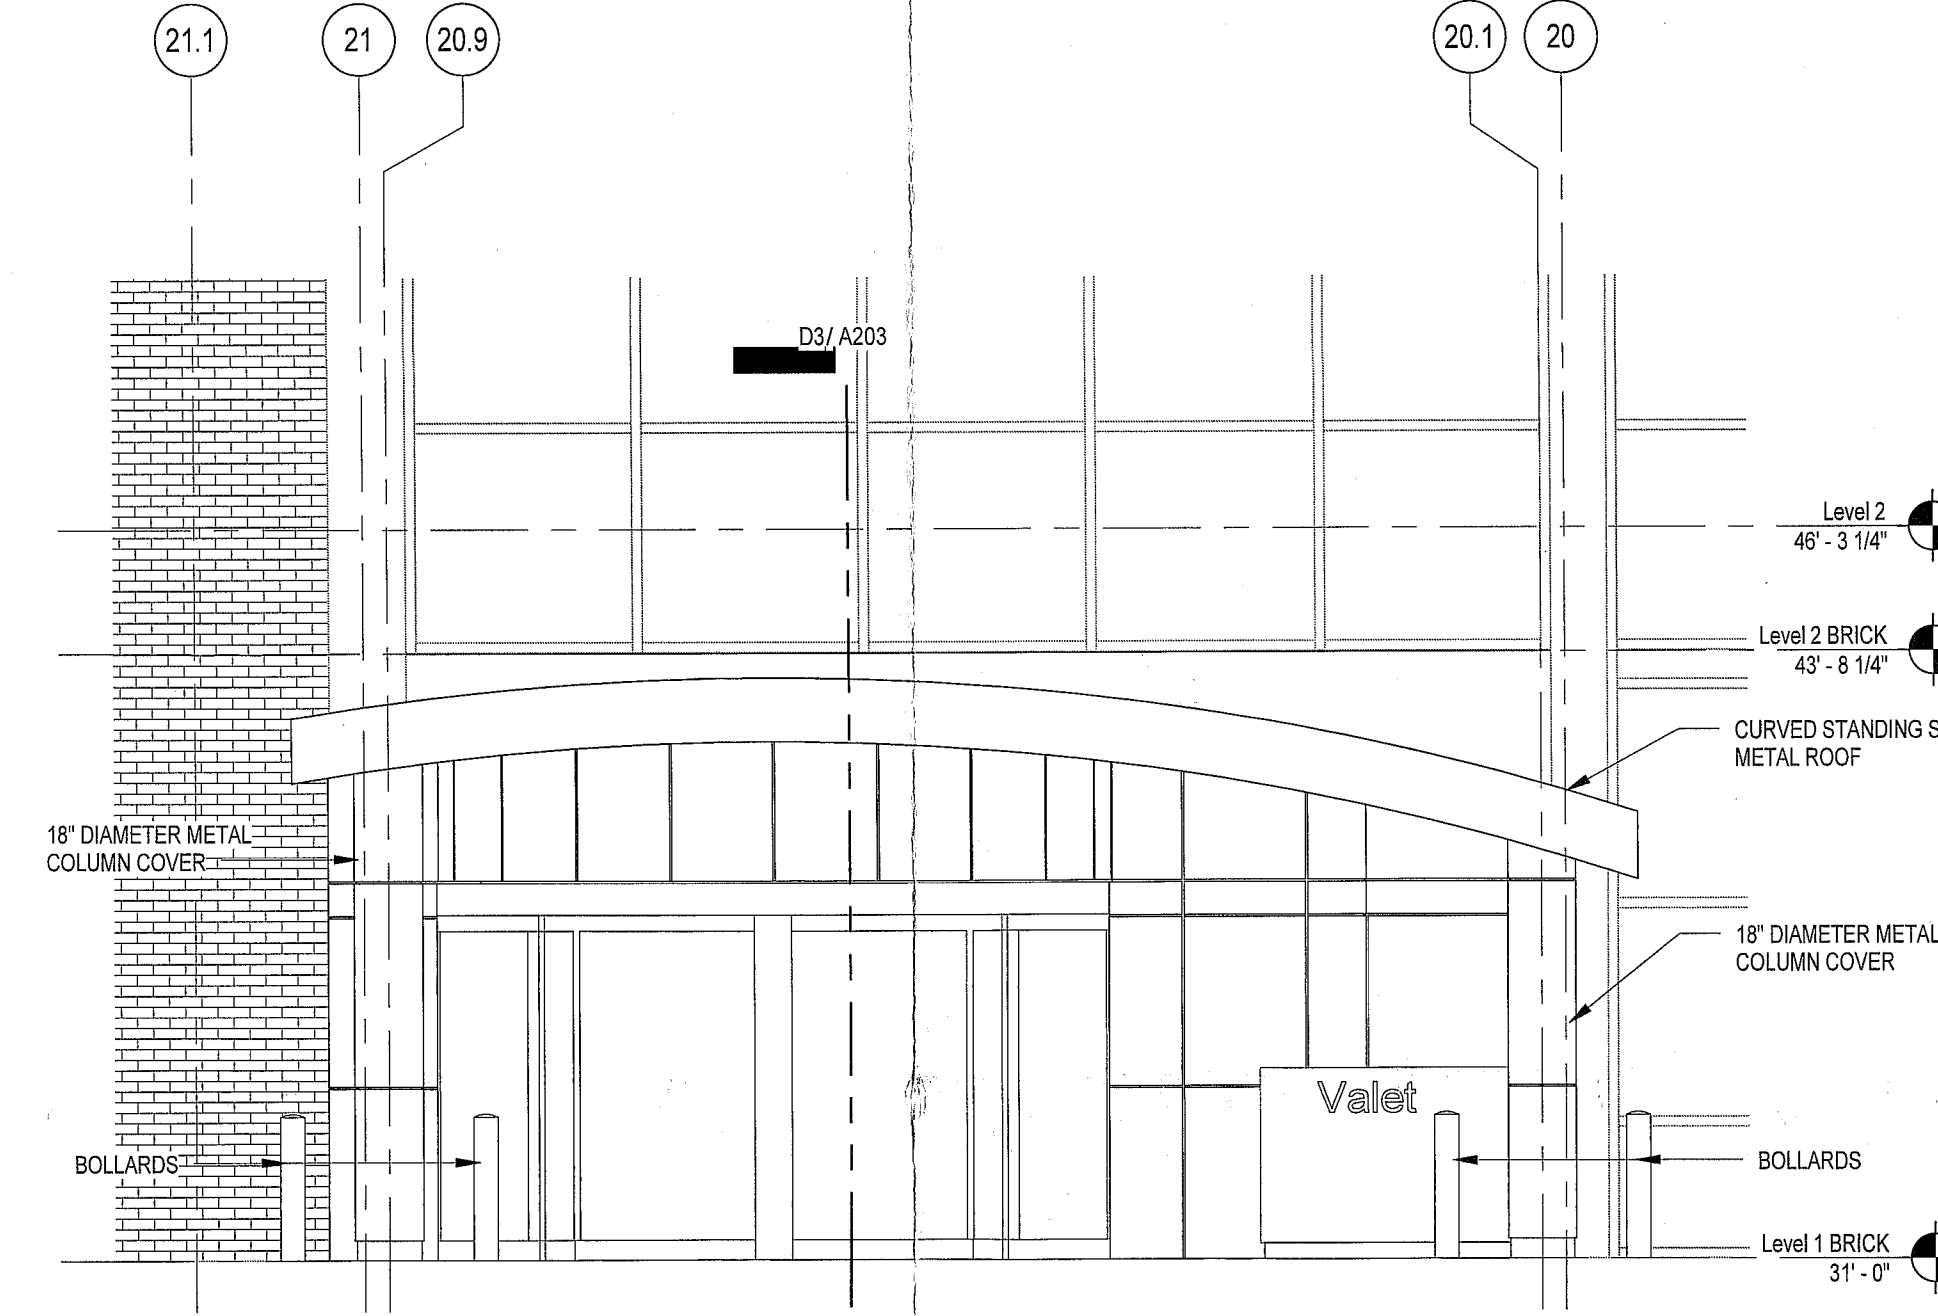


C4 CANOPY WEST ELEVATION
SCALE: 1/4" = 1'-0"

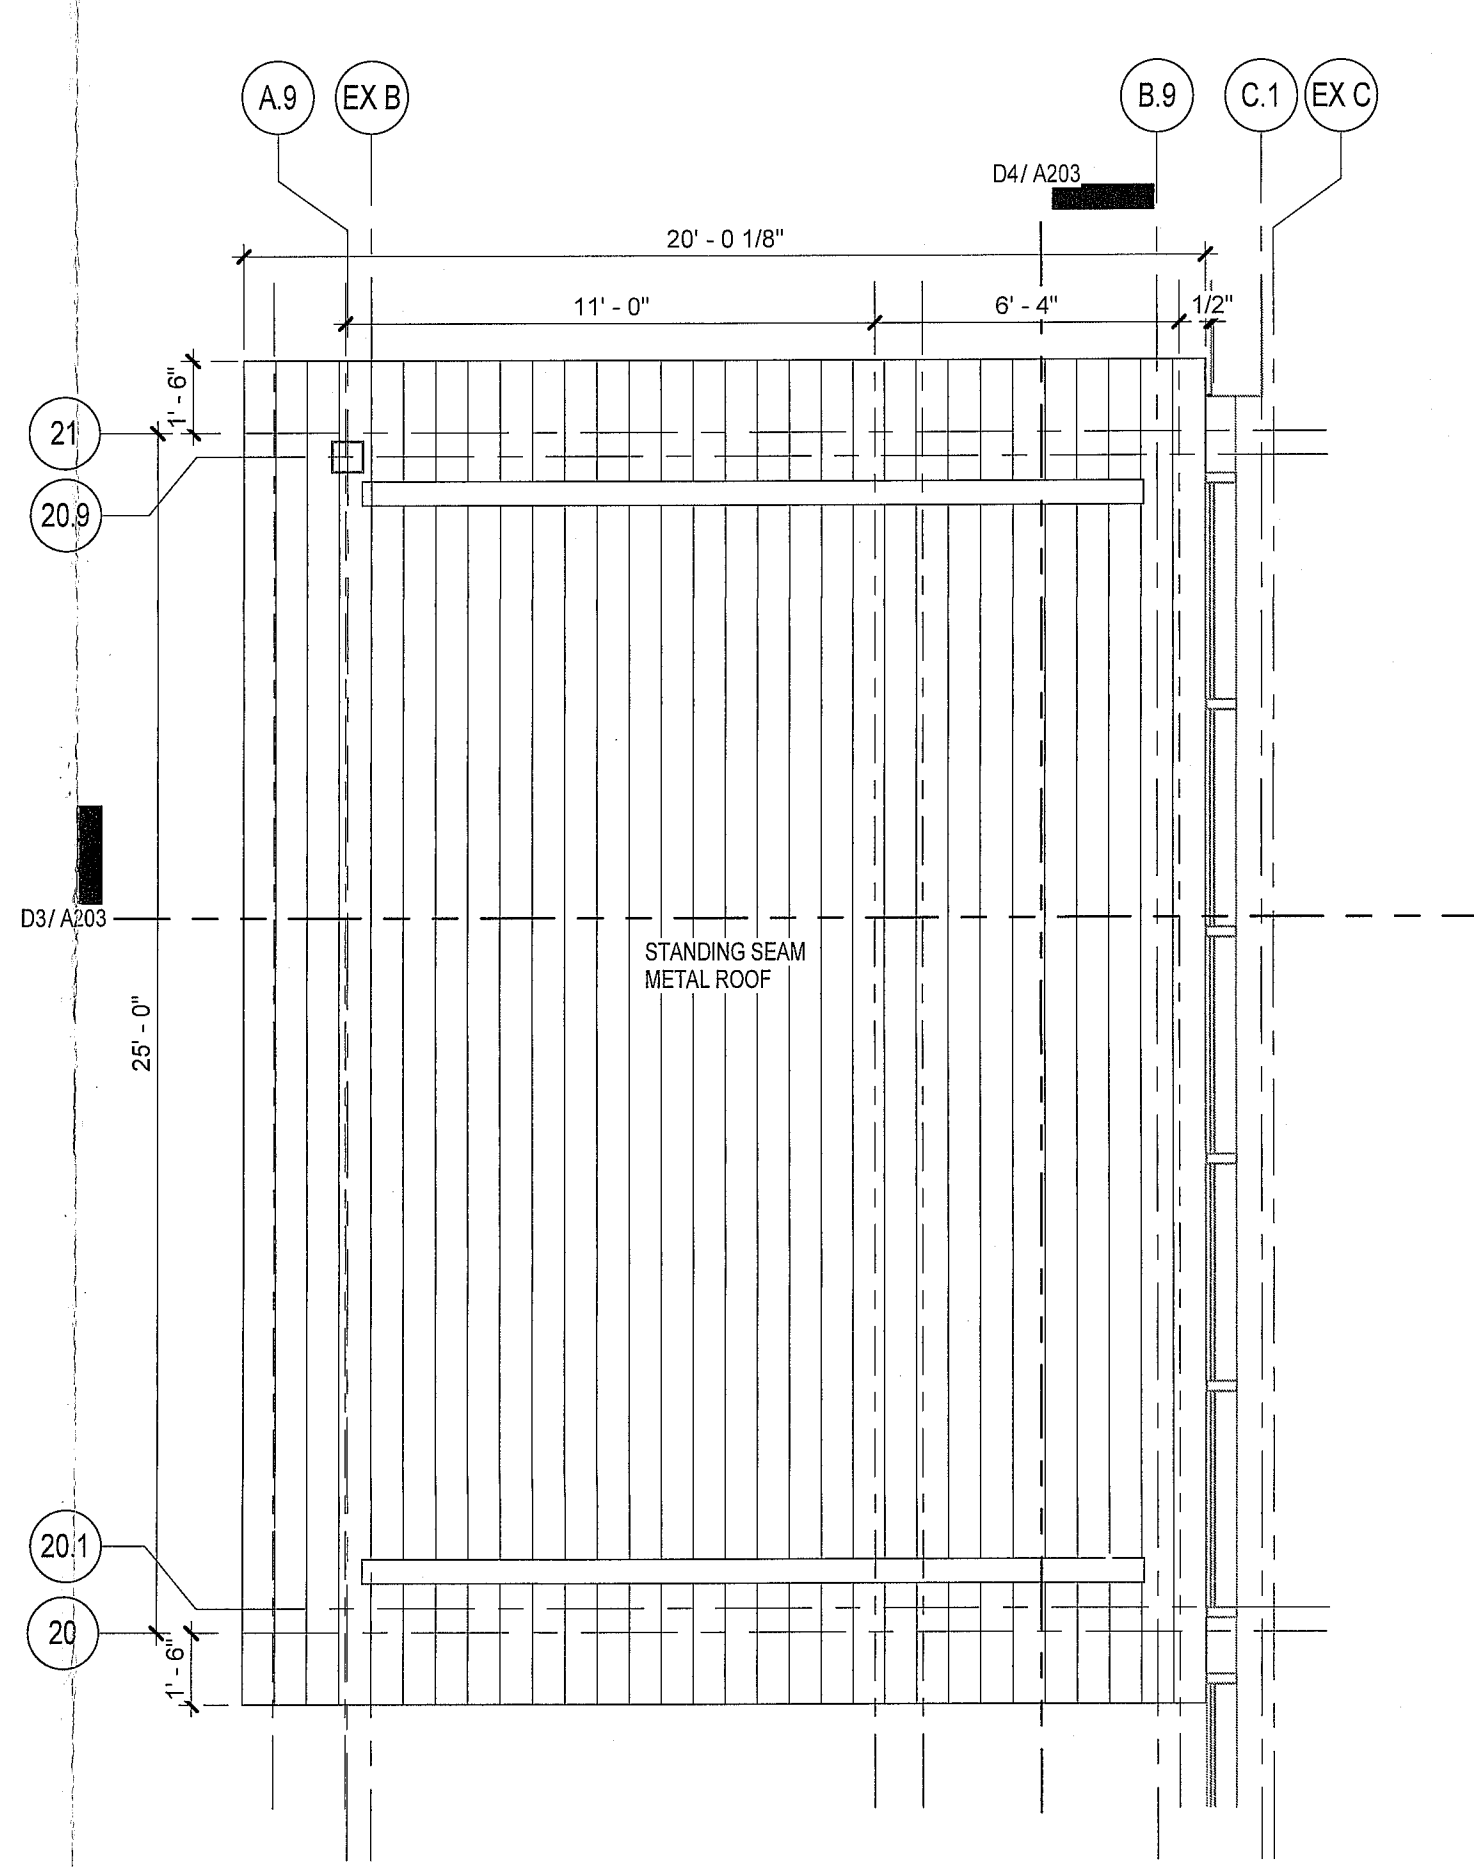

A2 CANOPY ROOF PLAN
SCALE: 1/4" = 1'-0"

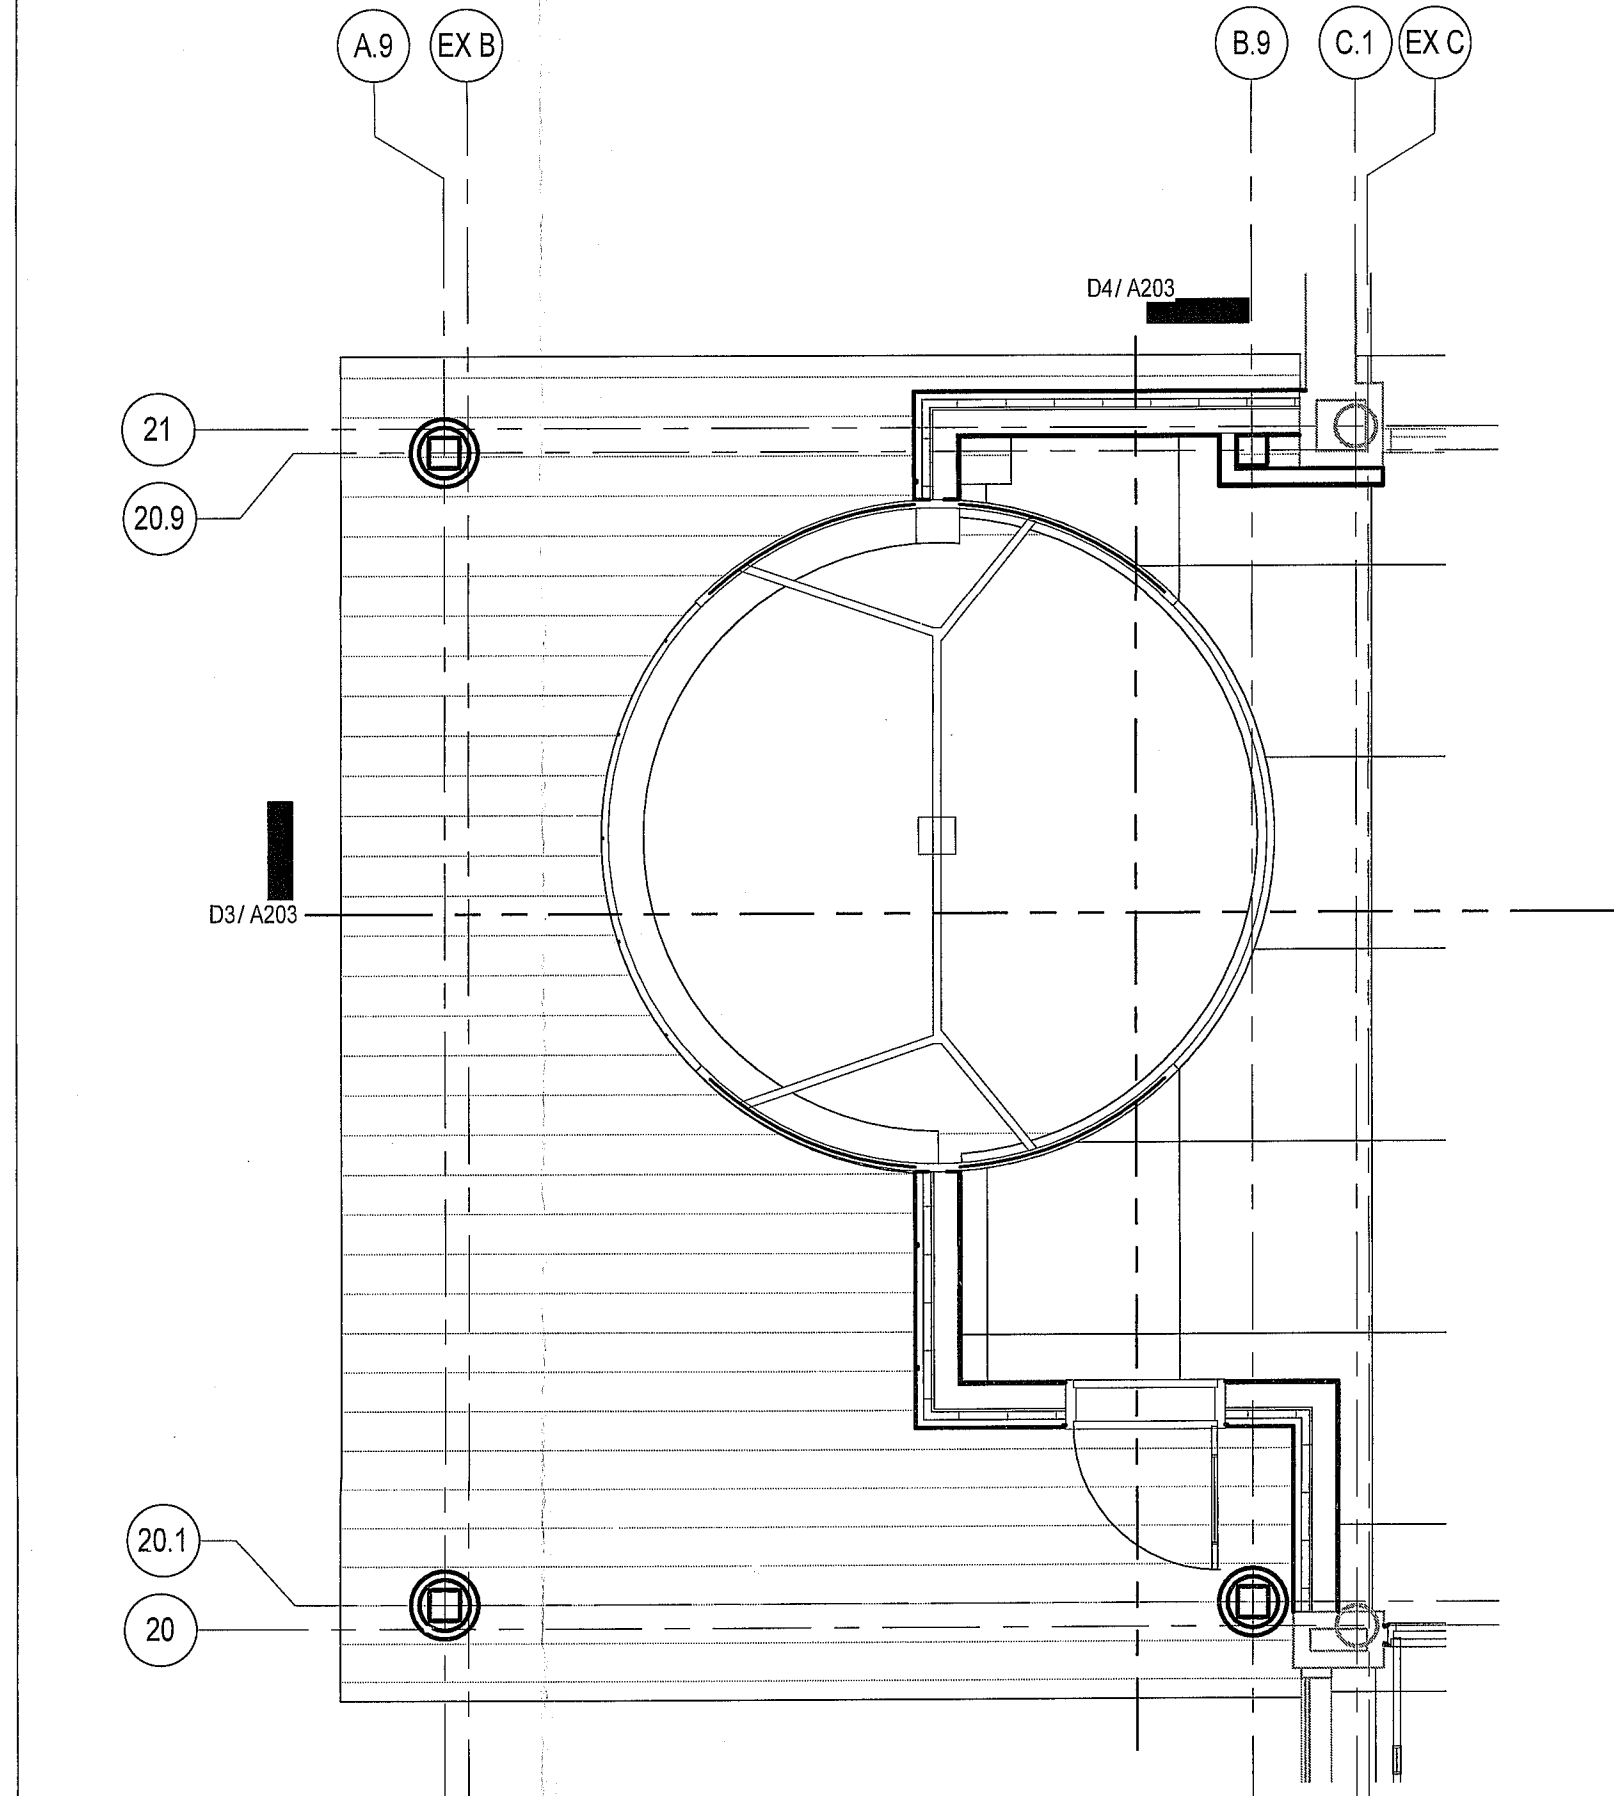

A3 CANOPY SOFFIT/CEILING PLAN
SCALE: 1/4" = 1'-0"

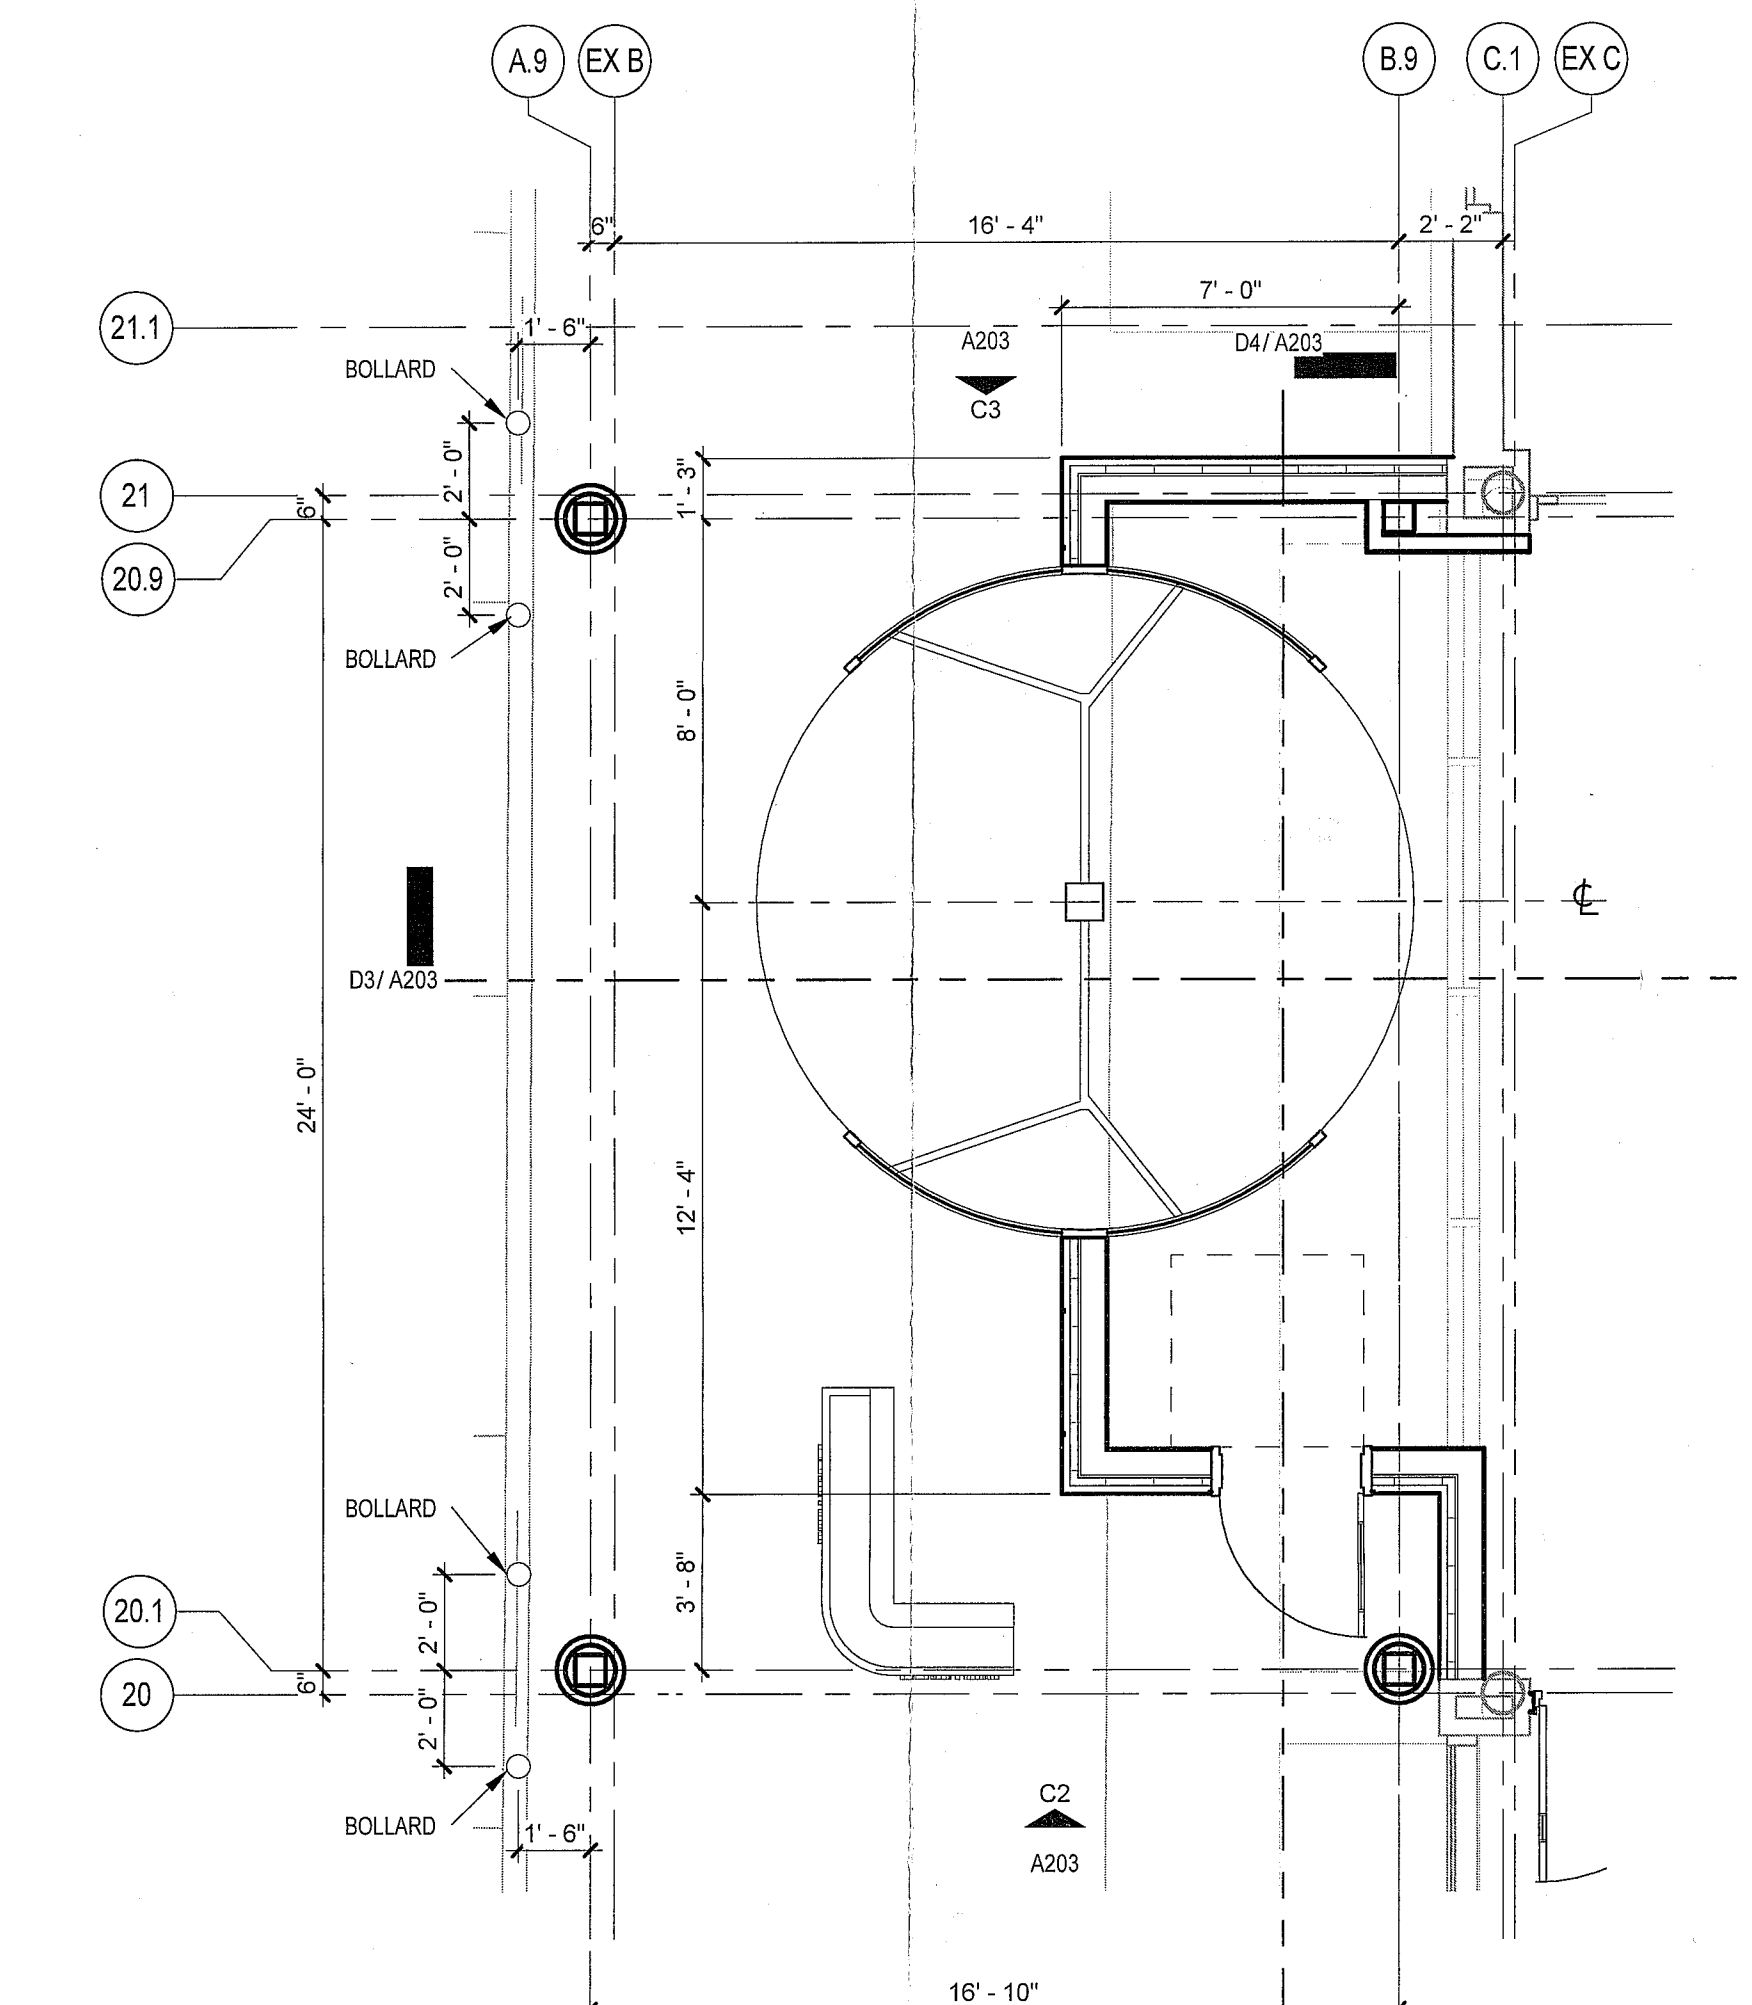


A4 CANOPY FLOOR PLAN
SCALE: 1/4" = 1'-0"

WHR ARCHITECTS
Architecture with People in Mind

1111 Louisiana 26TH Floor
Houston, Texas 77002
713.665.5665 phone • whrarchitects.com

Revisions		
Revision Number	Revision Date	Revision Description

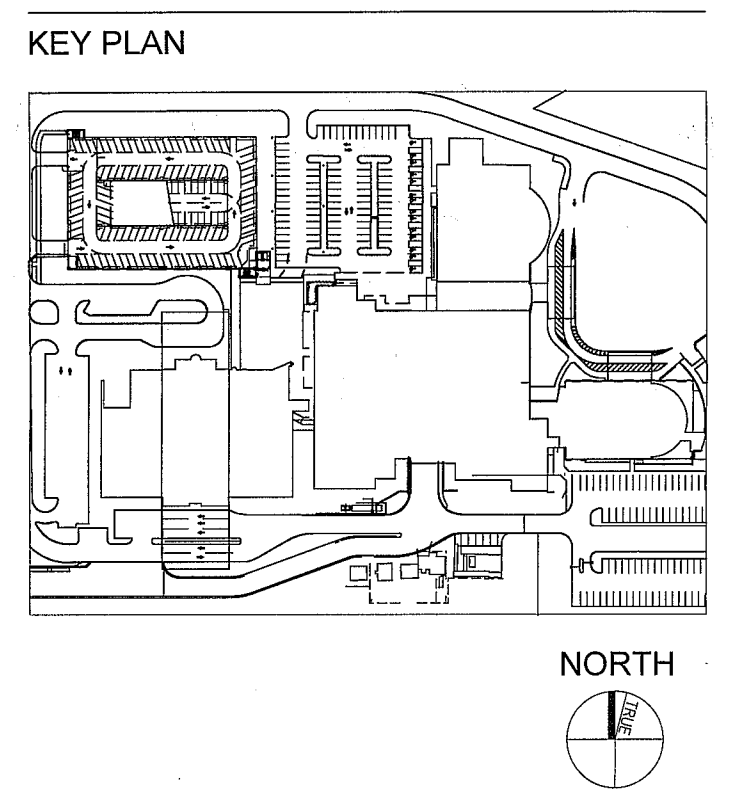

OUTPATIENT ONCOLOGY SERVICES EXPANSION



Ocean Medical Center

425 JACK MARTIN BLVD. BRICK, NEW JERSEY, 08742
OCA PROJECT #0009-15
Architect or Record: Charles H. Griffin, NJ Registration No. 15576

Charles H. Griffin
Architect

CANOPY ELEVATIONS,
SECTIONS, AND DETAIL

PHASE: CD
DATE: 03-13-2015
PROJECT NO. H146005-00

A203

8/13/2015 12:04:51 PM


Drawing Index

General

G-001 COVER SHEET
G-002 GENERAL INFORMATION AND ZONING DATA

Civil

C-100 OVERALL SITE LAYOUT PLAN
C-101 SITE LAYOUT PLAN
C-102 GRADING PLAN
C-103 EXISTING LIGHTING PLAN
C-501 CONSTRUCTION DETAILS

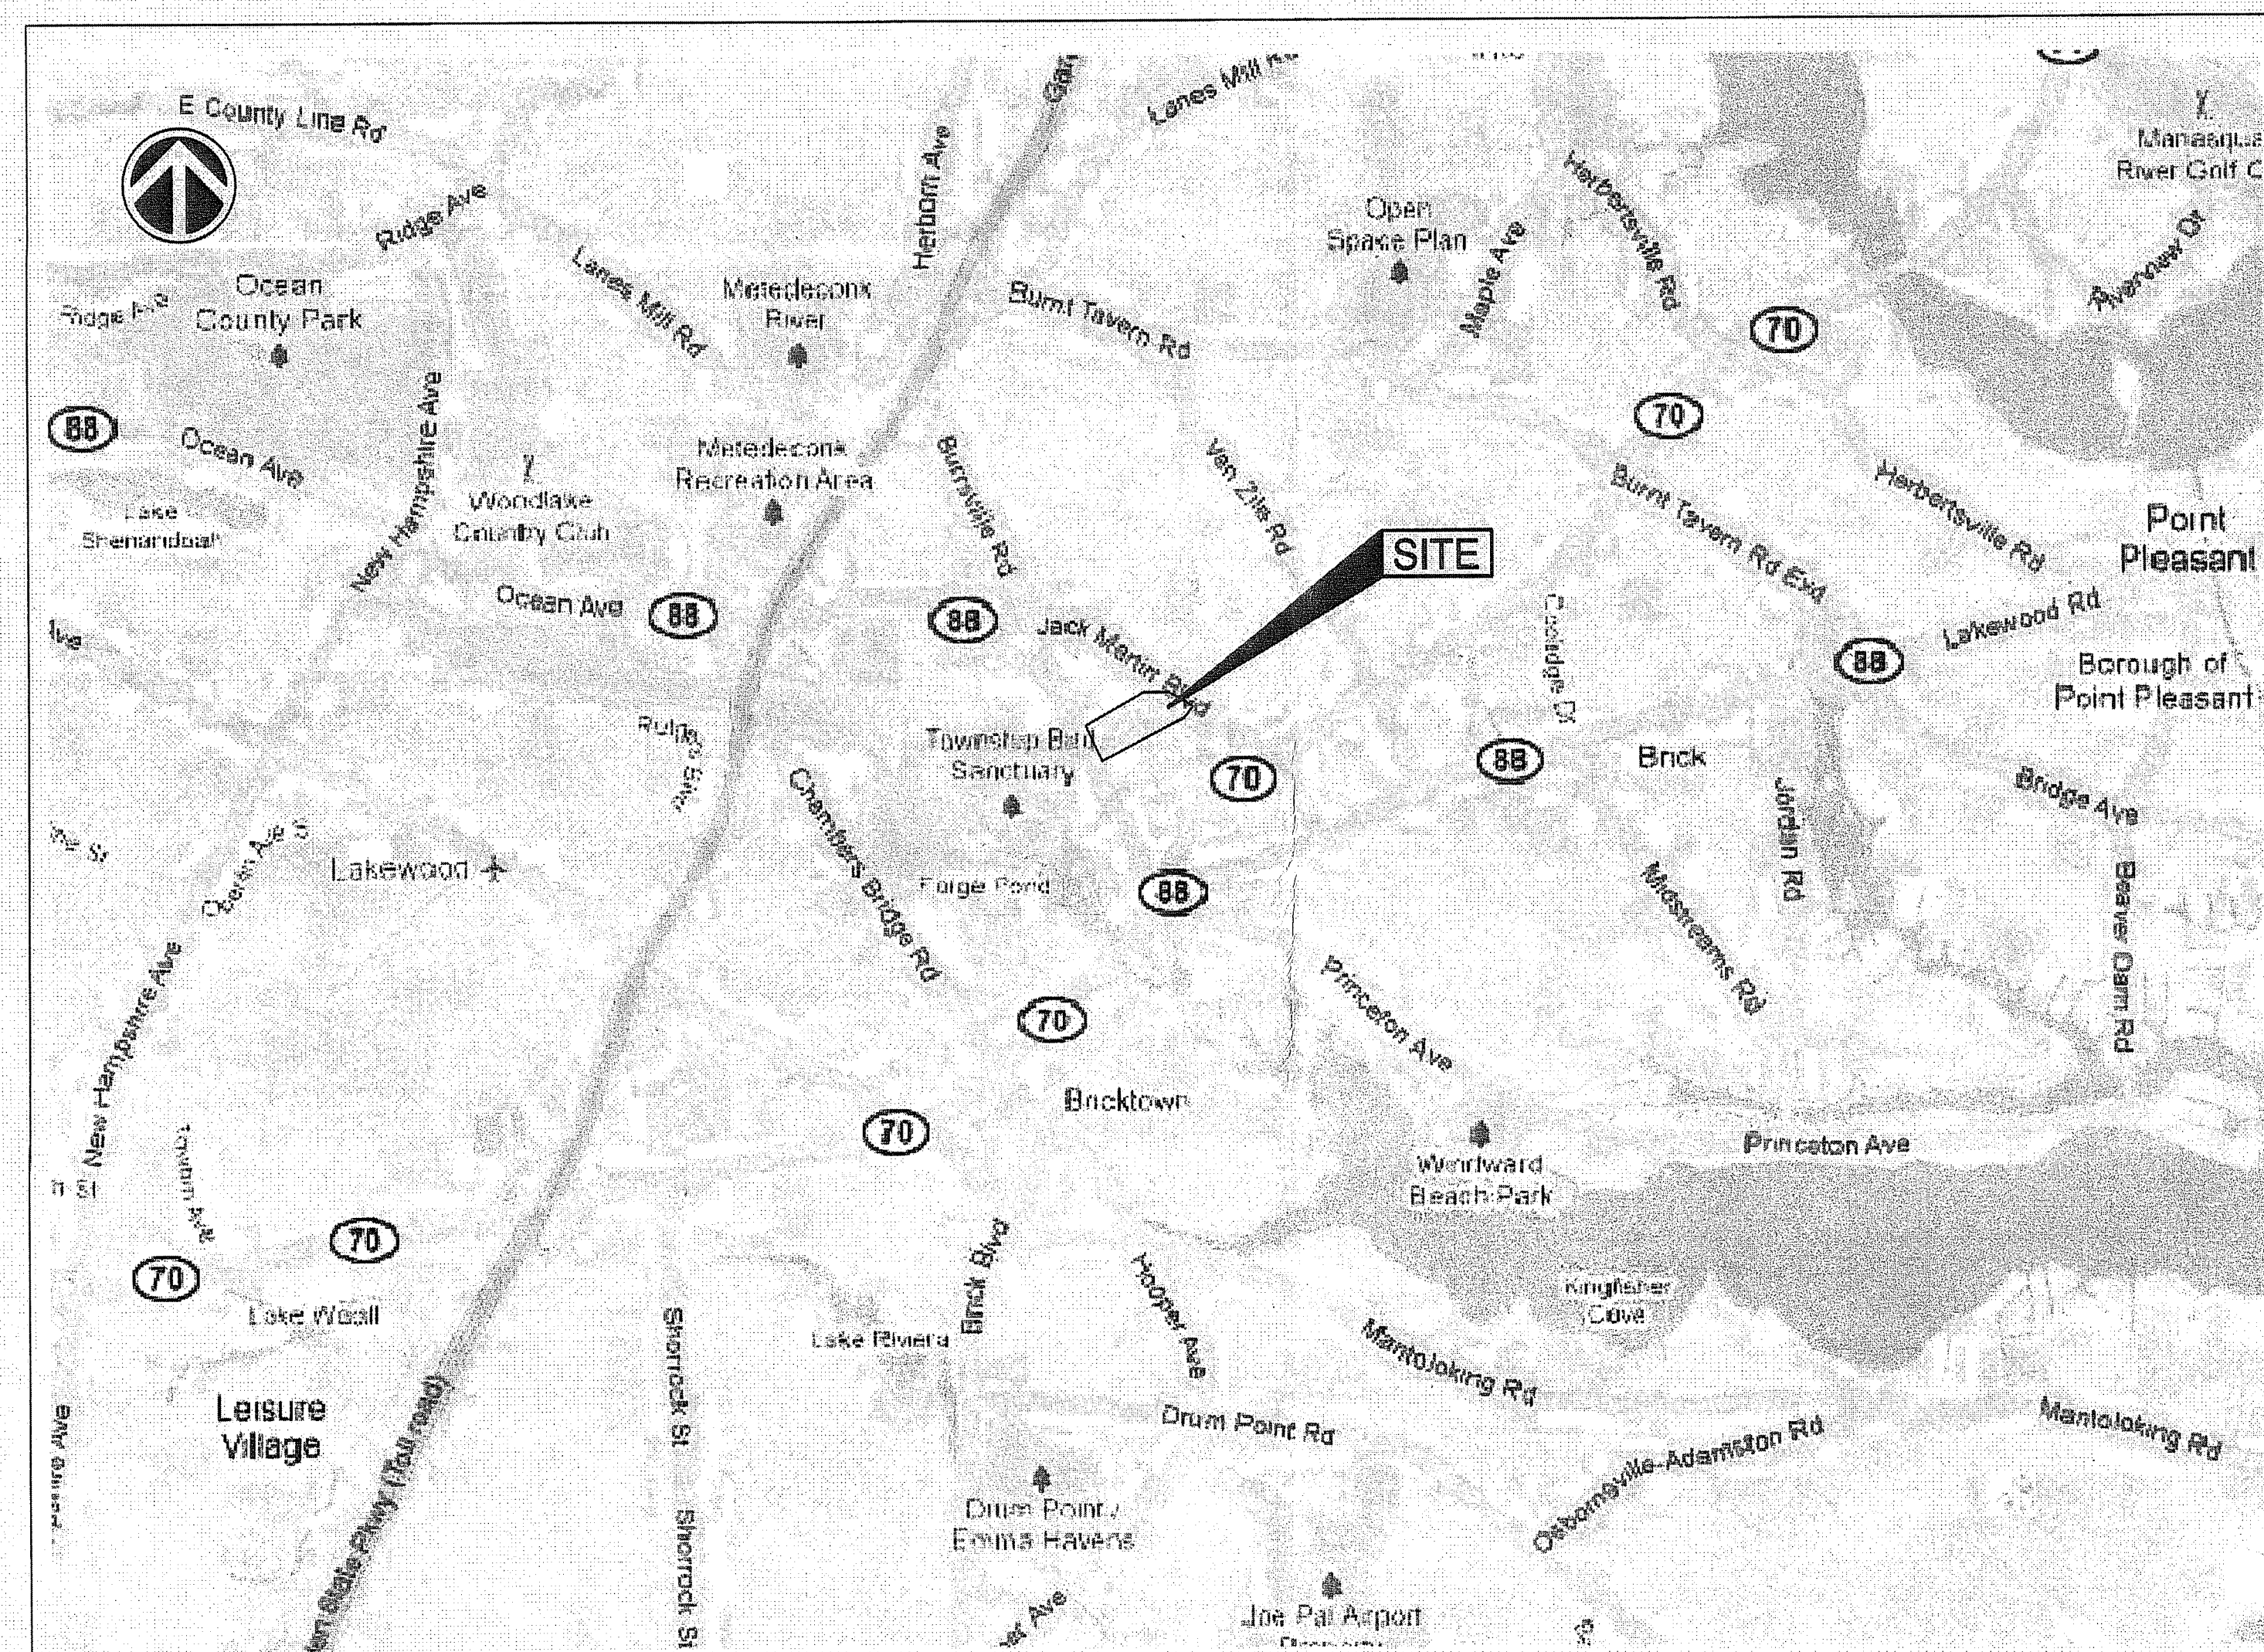

Scale: 1"=2500'±

AMENDED FINAL SITE PLAN FOR OCEAN MEDICAL CENTER ONCOLOGY ENTRANCE IMPROVEMENTS

425 JACK MARTIN BOULEVARD
TOWNSHIP OF BRICK
OCEAN COUNTY, NEW JERSEY

Tax Map Block 1170, Lot 18 & 18.02
HS ZONE - HOSPITAL SUPPORT ZONE

OCEAN COUNTY PLANNING BOARD
FINAL SITE PLAN APPROVAL
DATE: 8/16/15
BY: [Signature]

Owner & Applicant

OCEAN MEDICAL CENTER
425 JACK MARTIN BOULEVARD
BRICK, NEW JERSEY 08724

Approvals

OCEAN COUNTY PLANNING BOARD APPROVAL	
DATE	CHAIRMAN
BRICK TOWNSHIP ENGINEERING DEPARTMENT	
DATE	TOWNSHIP ENGINEER

THIS SITE FOR WHICH AMENDED FINAL SITE PLAN APPROVAL WAS GRANTED BY THE BRICK TOWNSHIP PLANNING BOARD VIA APPROVAL RESOLUTION R-7-11 SHALL BE MAINTAINED AS ORIGINALLY APPROVED.	
APPROVED BY BRICK TOWNSHIP PLANNING BOARD	
DATE	CHAIRMAN
DATE	SECRETARY
DATE	BOARD ENGINEER



Dewberry Engineers Inc.
600 PARSONS ROAD
SUITE 301
PARSONS, NJ 07654
973.738.5400 Phone
973.738.5710 Fax

Certificate of Authorization #24048047600

OWNER:



APPLICANT:

ARCHITECT:

SEAL:


Christopher M. Cirrotti, P.E.

New Jersey License No. 24048047600

JUNE 7, 2016

SUBMISSION DATE

 PB 2769-A-FSP 8/15



1. DRAINING ENTITLED "BOUNDARY SURVEY WITH TOPOGRAPHY AND UTILITIES FOR MERIDIAN HEALTH BLOCK 1170-LOTS 18 & 18.02 TOWNSHIP OF BRICK OCEAN COUNTY, NEW JERSEY" DATED 04.29.11 BY DEMBERRY.
2. DRAININGS ENTITLED "AMENDED PRELIMINARY AND FINAL SITE PLAN FOR OCEAN MEDICAL CENTER" DATED OCTOBER 18, 2013 BY DEMBERRY.
3. FIELD SURVEY ENTITLED "PARTIAL TOPOGRAPHIC SURVEY OCEAN MEDICAL CENTER BLOCK 1170 LOTS 18 & 18.02 TOWNSHIP OF BRICK OCEAN COUNTY, NEW JERSEY" DATED AUGUST 6, 2015 BY DEMBERRY.
4. ERROR OF BOUNDARY CLOSURE IS LESS THAN 1:10,000

8/2/16 *Bernard J. Coste*
DATE CHAIRMAN
11/1/16 *Christine D. Dyer*
ATTEST SECRETARY
8/1/16 *[Signature]*
DATE BOARD ENGINEER

TE TOWNSHIP ENGINEER


Ocean Medical Center
MEMBER OF THE METROHEALTH FAMILY

AMENDED FINAL
SITE PLAN FOR
OCEAN MEDICAL CENTER
ONCOLOGY ENTRANCE IMPROVEMENTS
BLOCK 1170, LOTS 18, 18.02
CITY OF JACKSON, NEW JERSEY
BRICK TOWNSHIP, OCEAN COUNTY, NEW JERSEY

SEAL

Christopher M. Cirrotti, P.E.
New Jersey License No. 24GE03553800

KEY PLAN

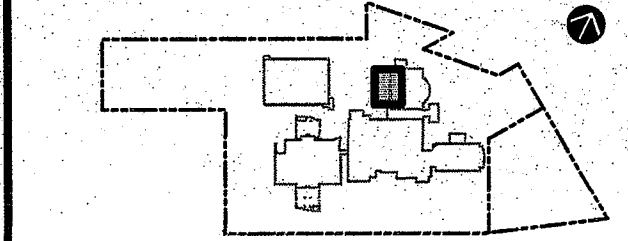

SCALE

2	02.22.16	SP	FILED COMMENTS
1	09.15.15	SP	REV. PER COMPLETENESS
No.	DATE	BY	Description

REVISIONS

DRAWN BY	SLP
APPROVED BY	CC
CHECKED BY	MI
DATE	08.14.15


TITL

OVERALL
SITE
LAYOUT
PLAN

PROJECT NO.	50075663
-------------	----------

C-100

SHEET NO.

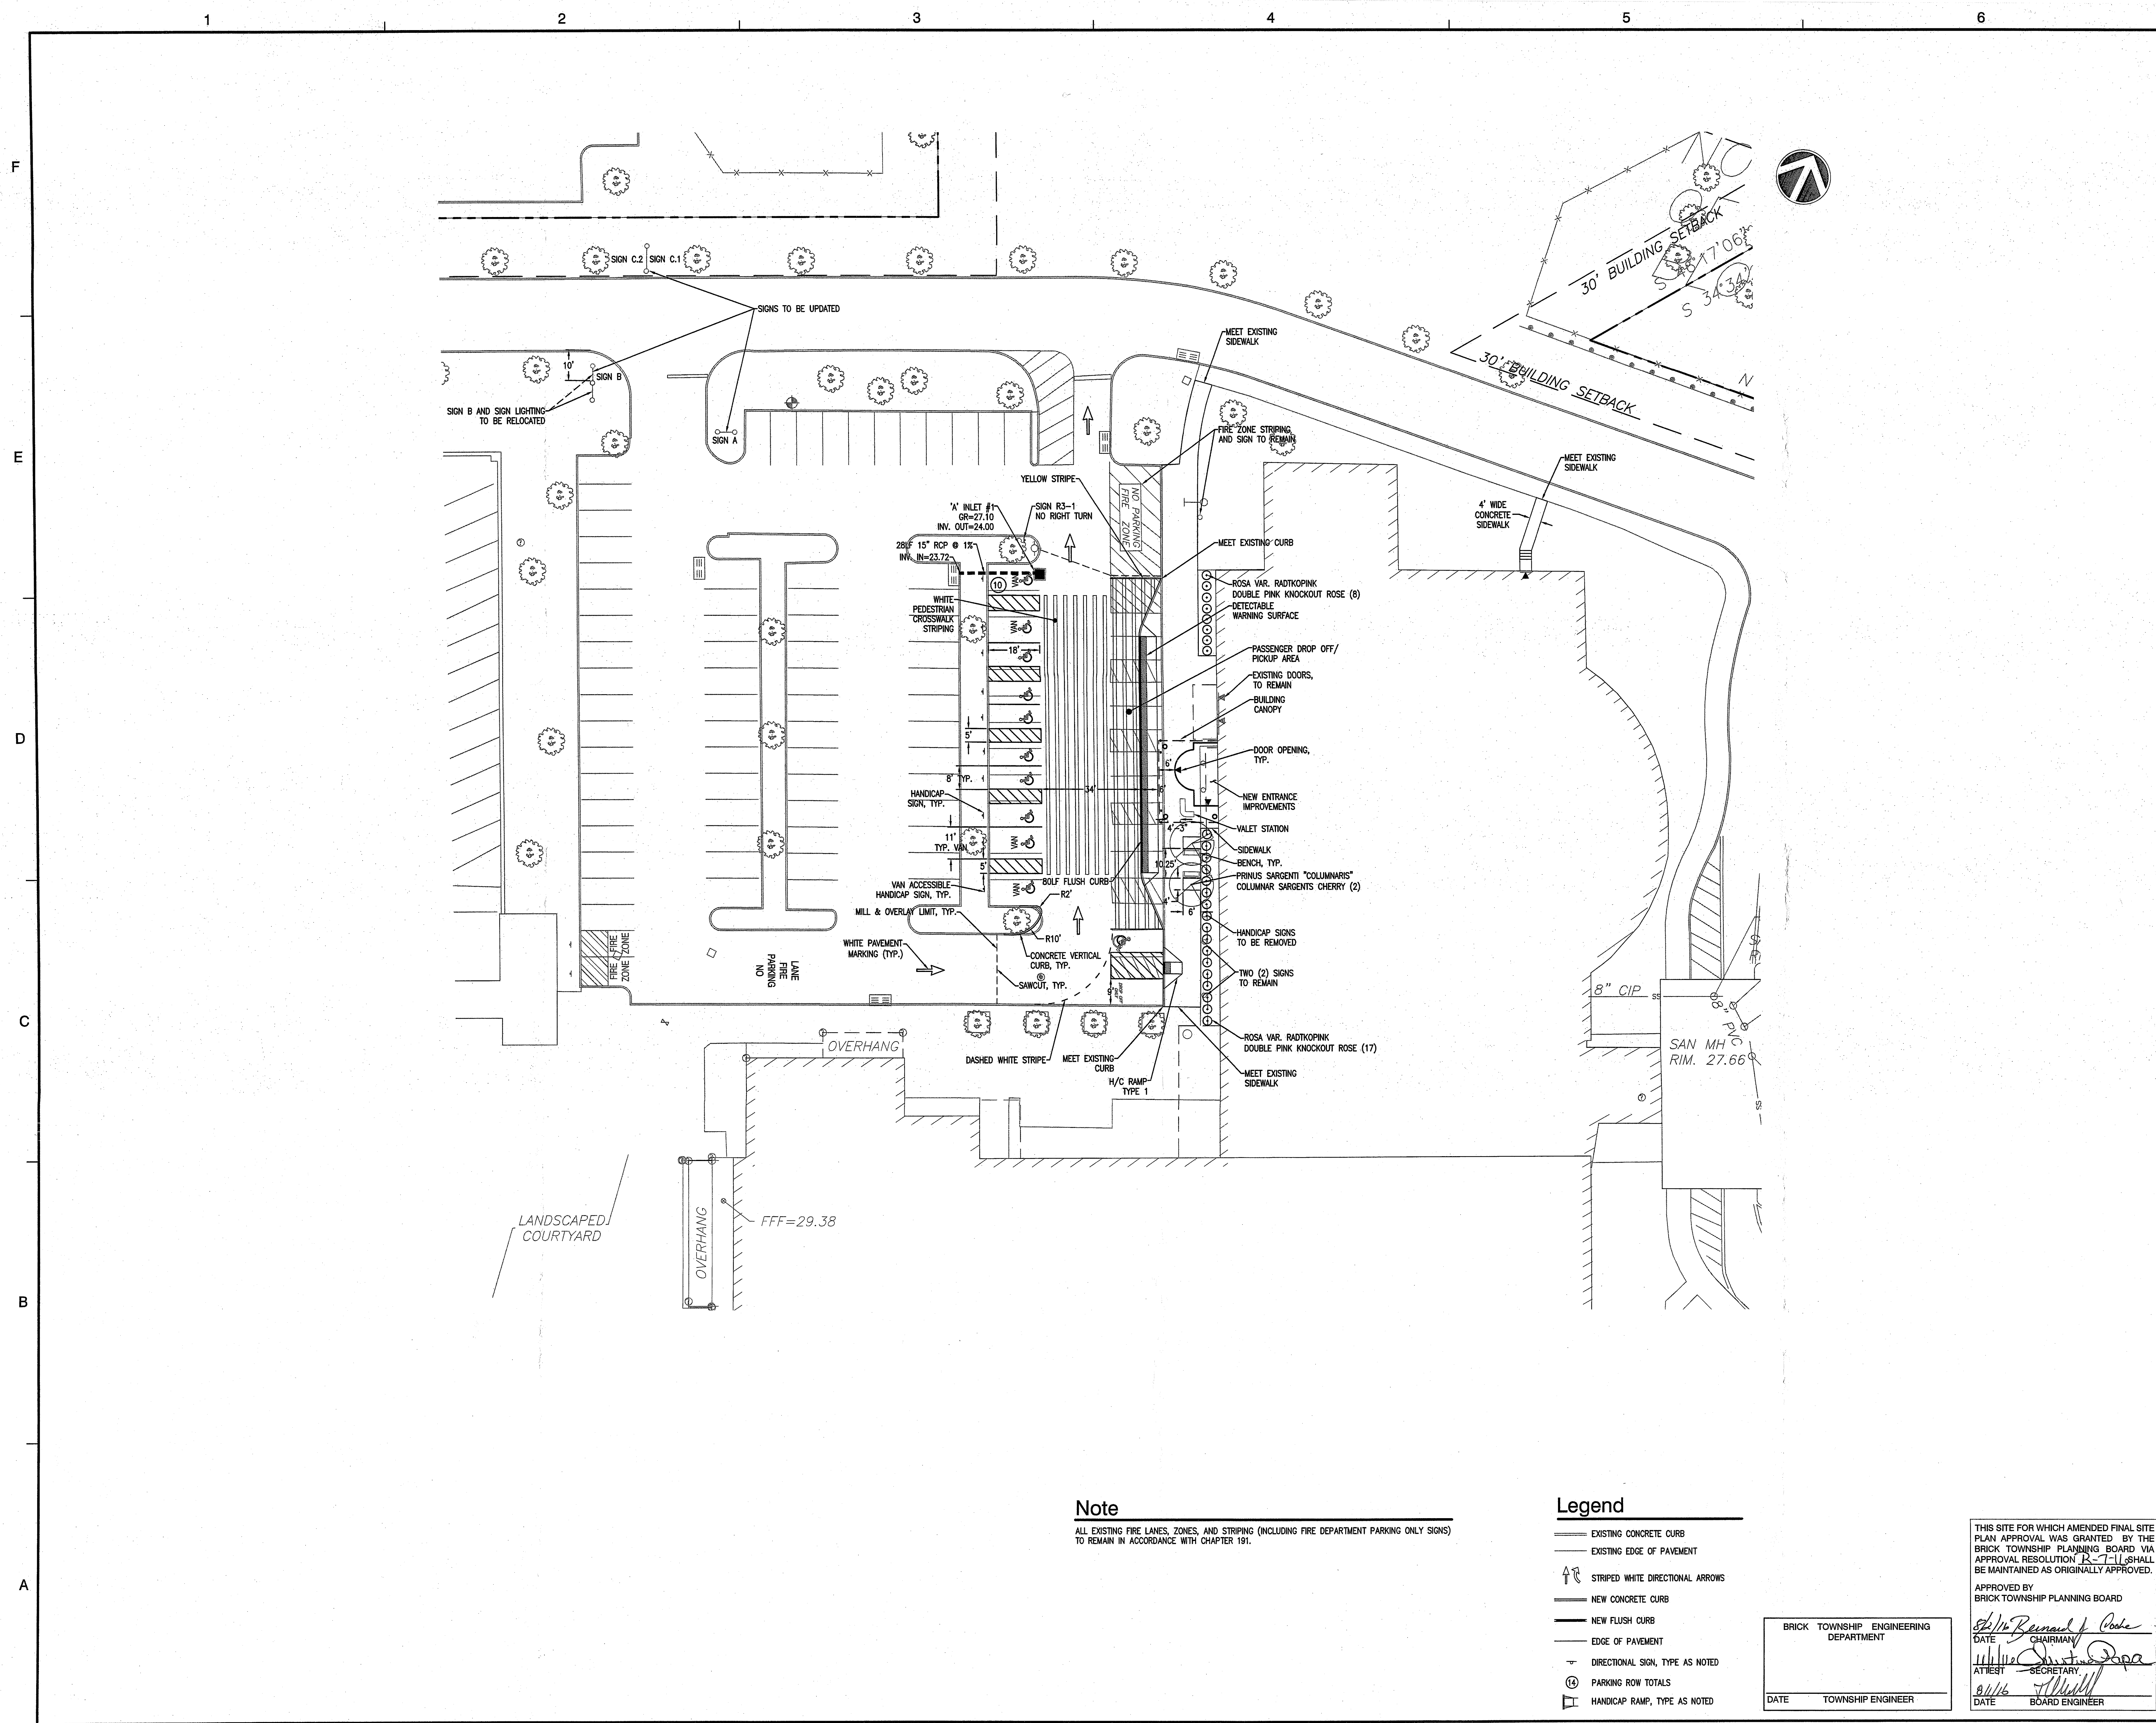

Note
ALL EXISTING FIRE LANES, ZONES, AND STRIPING (INCLUDING FIRE DEPARTMENT PARKING ONLY SIGNS) TO REMAIN IN ACCORDANCE WITH CHAPTER 191.

- Legend**
- EXISTING CONCRETE CURB
 - EXISTING EDGE OF PAVEMENT
 - STRIPED WHITE DIRECTIONAL ARROWS
 - NEW CONCRETE CURB
 - NEW FLUSH CURB
 - EDGE OF PAVEMENT
 - DIRECTIONAL SIGN, TYPE AS NOTED
 - PARKING ROW TOTALS
 - HANDICAP RAMP, TYPE AS NOTED

BRICK TOWNSHIP ENGINEERING DEPARTMENT

DATE _____

TOWNSHIP ENGINEER

THIS SITE FOR WHICH AMENDED FINAL SITE PLAN APPROVAL WAS GRANTED BY THE BRICK TOWNSHIP PLANNING BOARD VIA APPROVAL RESOLUTION R-7-11 SHALL BE MAINTAINED AS ORIGINALLY APPROVED.

APPROVED BY _____

DATE _____

CHAIRMAN

ATTEST _____

DATE _____

SECRETARY

BOARD ENGINEER



Dewberry Engineers Inc.
500 PASSICAWAY ROAD
SUITE 301
PASSICAWAY, NJ 07054
973.735.8400 Phone
973.735.8711 Fax

Certificate of Authorization #246A08047800





AMENDED FINAL
SITE PLAN FOR
OCEAN MEDICAL CENTER
ONCOLOGY ENTRANCE IMPROVEMENTS
BLOCK 1170, LOTS 18, 18.02
425 JACK MARTIN BOULEVARD
BRICK TOWNSHIP, OCEAN COUNTY, NEW JERSEY

SEAL

Christopher M. Cirrotti, P.E.

Christopher M. Cirrotti, P.E.
New Jersey License No. 2460353380

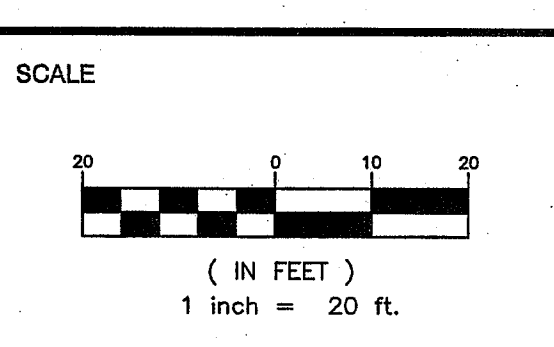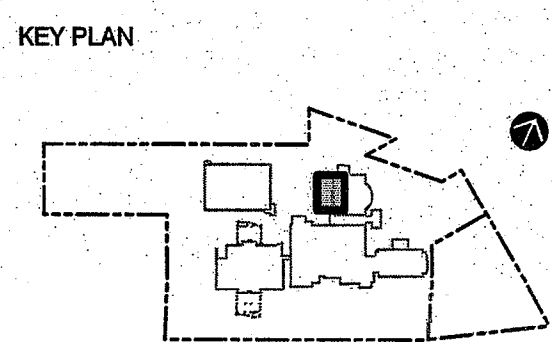

No.	DATE	BY	Description
1	02.22.16	SP	PLSD COMMENTS
2	04.12.16	SP	BOARD ENGINEERS COMMENTS
3	05.18.16	SP	TOWNSHIP COMMENTS
4	06.07.16	SP	TOWNSHIP COMMENTS

REVISIONS

DRAWN BY _____ SLP

APPROVED BY _____ CC

CHECKED BY _____ MI

DATE _____ 08.14.16

TITLE

SITE LAYOUT PLAN

PROJECT NO. 50075683

C-101

SHEET NO.


AMENDED FINAL
SITE PLAN FOR
OCEAN MEDICAL CENTER
ONCOLOGY ENTRANCE IMPROVEMENTS
BLOCK 1170, LOTS 18, 18.02
455 JACK MARTIN BOULEVARD
BRICK TOWNSHIP, OCEAN COUNTY, NEW JERSEY

SEAL




Christopher M. Cirro, P.E.
New Jersey License No. 24620853800

KEY PLAN

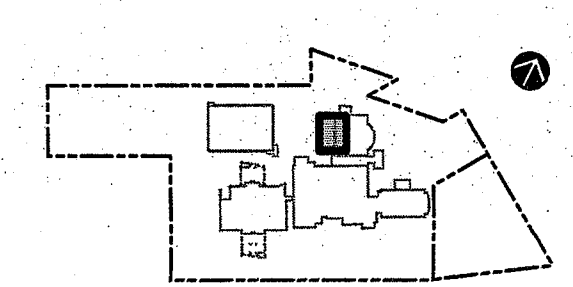

SCALE

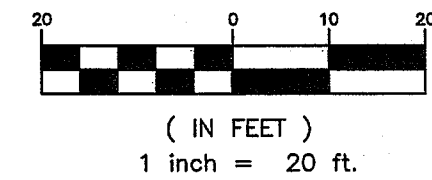

No.	DATE	BY	Description
4	06.07.16	SP	TOWNSHIP COMMENTS
3	05.16.16	SP	TOWNSHIP COMMENTS
2	04.12.16	SP	BOARD ENGINEERS COMMENTS
1	02.22.16	SP	PLSD COMMENTS

REVISIONS

DRAWN BY SLP

APPROVED BY CC

CHECKED BY MI

DATE 08.14.16



TITLE

GRADING
PLAN

PROJECT NO. 50075663

C-102

SHEET NO.

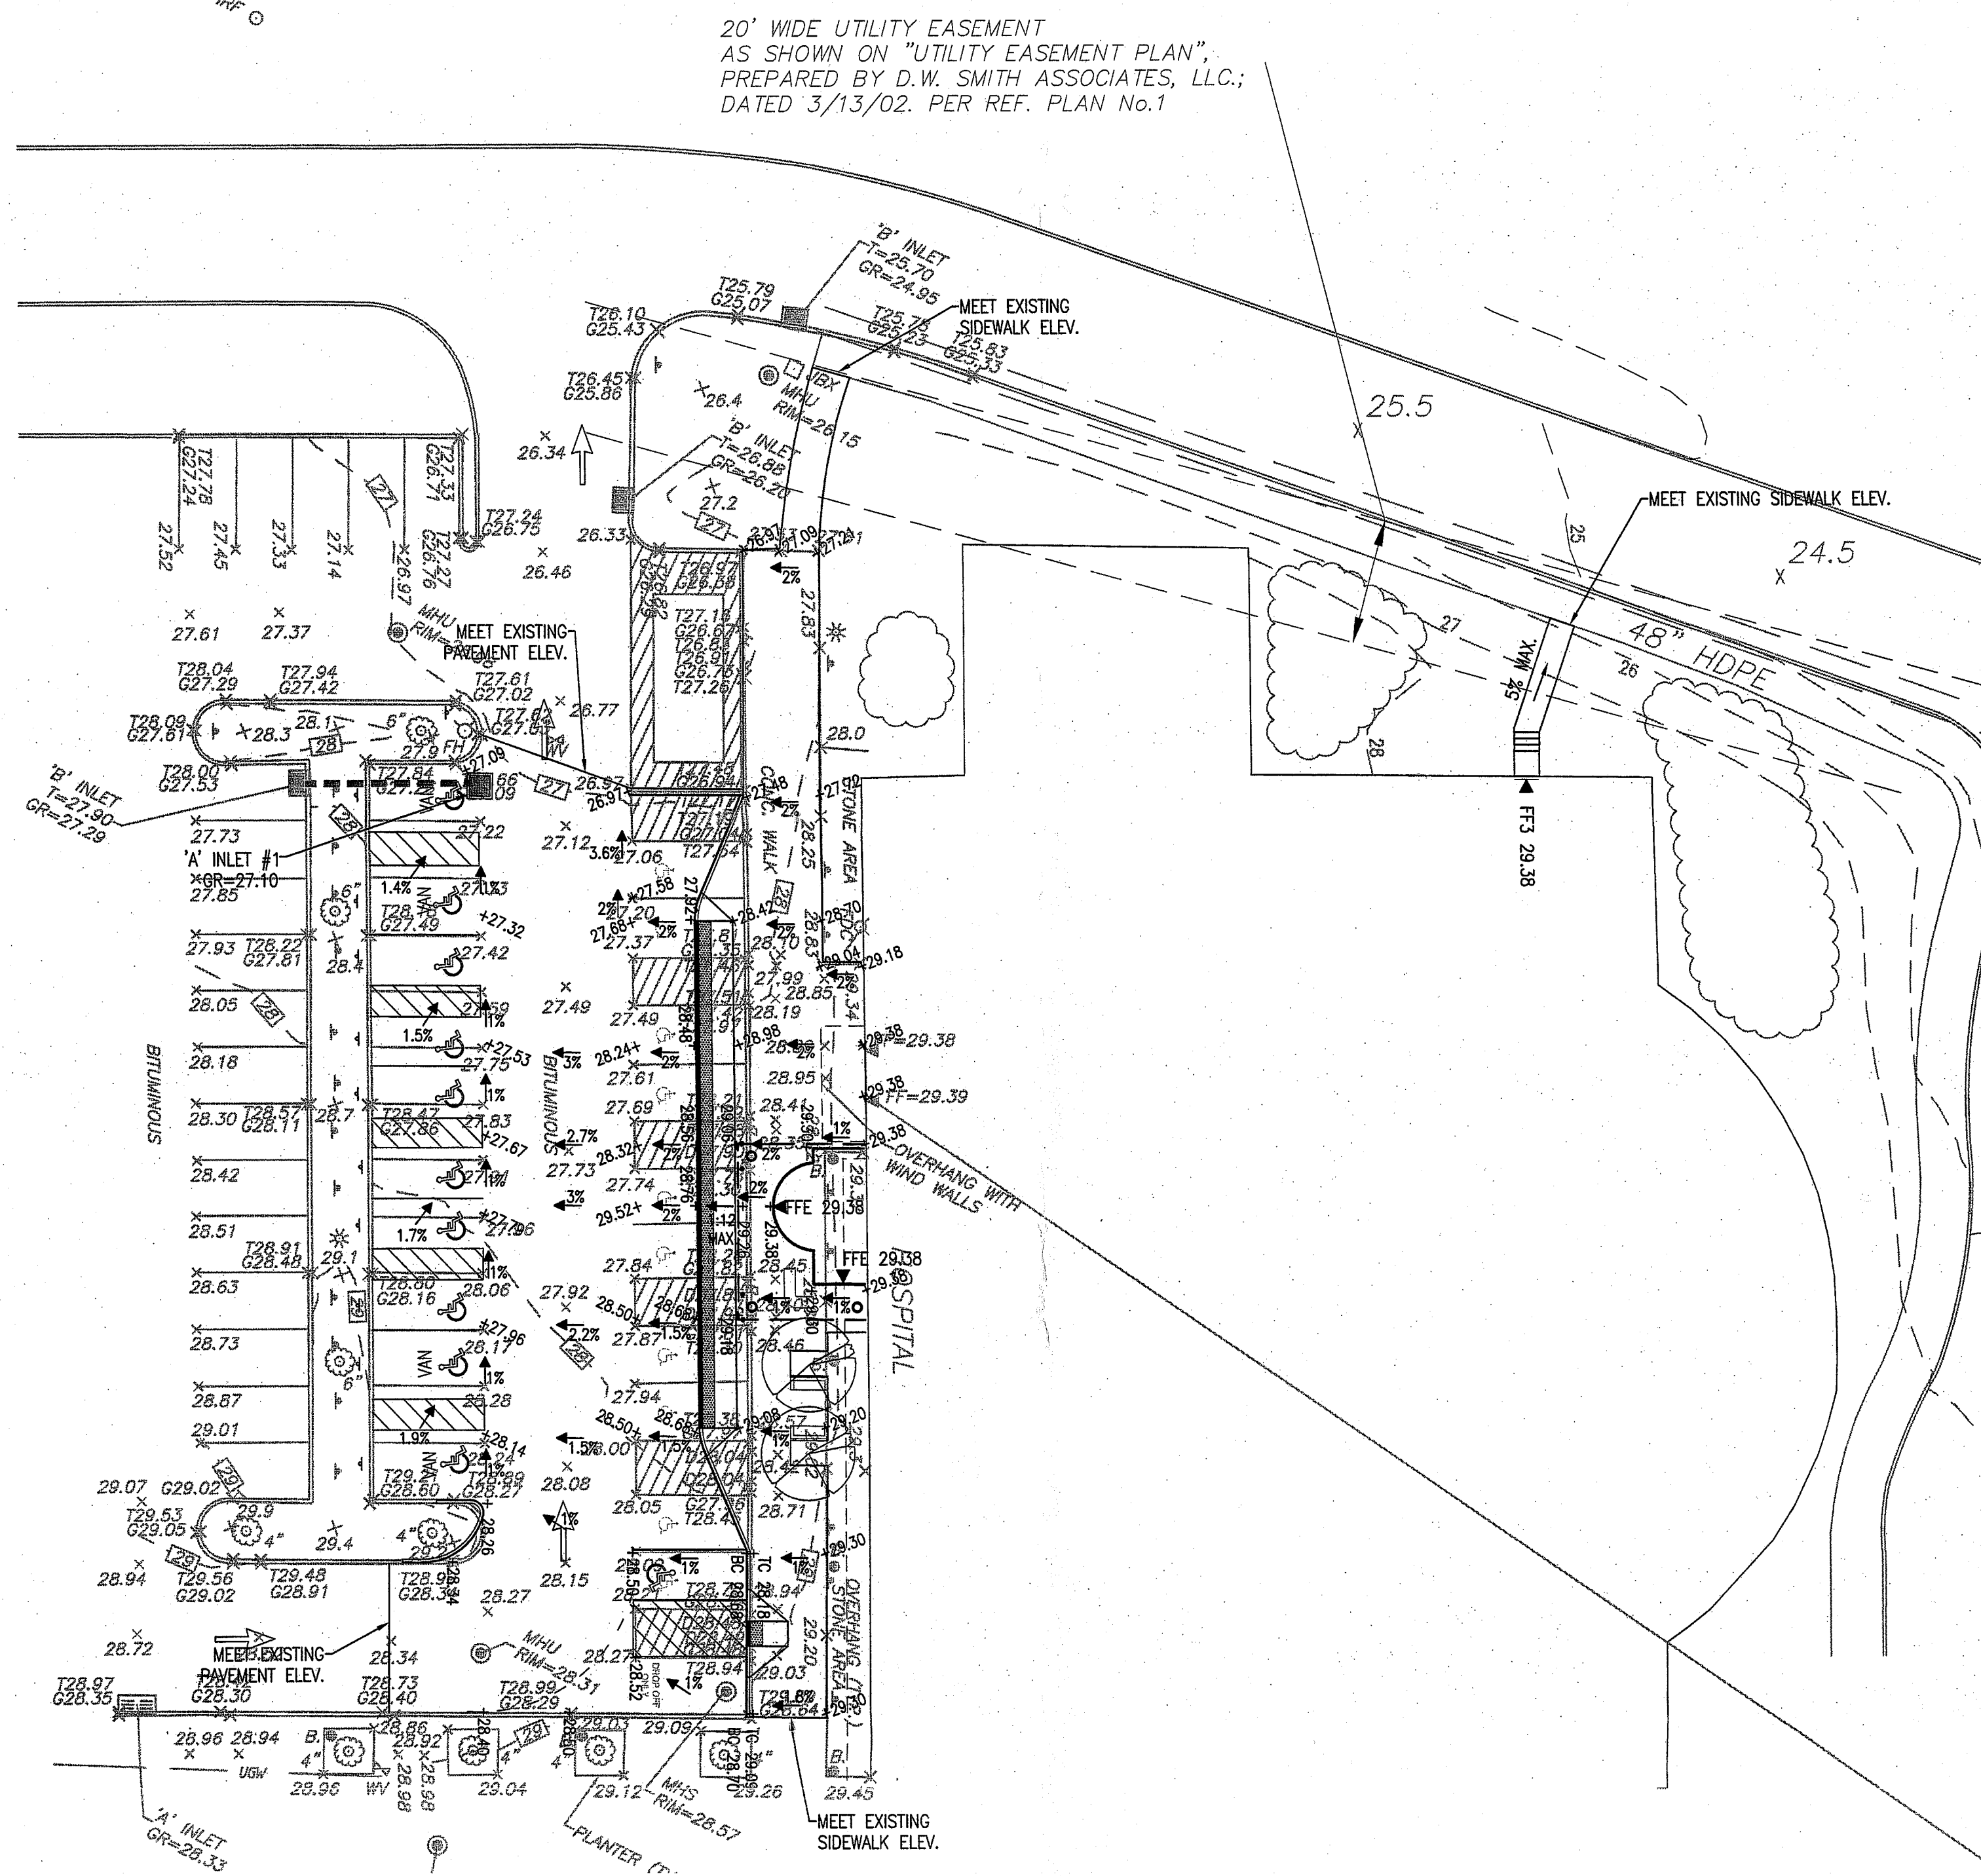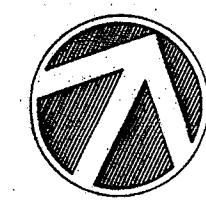


Legend

- EXISTING CONCRETE CURB
- EXISTING EDGE OF PAVEMENT
- STRIPED WHITE DIRECTIONAL ARROWS
- NEW CONCRETE CURB
- NEW FLUSH CURB
- EDGE OF PAVEMENT
- DIRECTIONAL SIGN, TYPE AS NOTED
- PARKING ROW TOTALS
- HANDICAP RAMP, TYPE AS NOTED

THIS SITE FOR WHICH AMENDED FINAL SITE
PLAN APPROVAL WAS GRANTED BY THE
BRICK TOWNSHIP PLANNING BOARD VIA
APPROVAL RESOLUTION R-7-16 SHALL
BE MAINTAINED AS ORIGINALLY APPROVED.

APPROVED BY
BRICK TOWNSHIP PLANNING BOARD
DATE 8/16/16
CHAIRMAN
ATTEST
8/16/16
BOARD ENGINEER

BRICK TOWNSHIP ENGINEERING
DEPARTMENT
DATE
TOWNSHIP ENGINEER

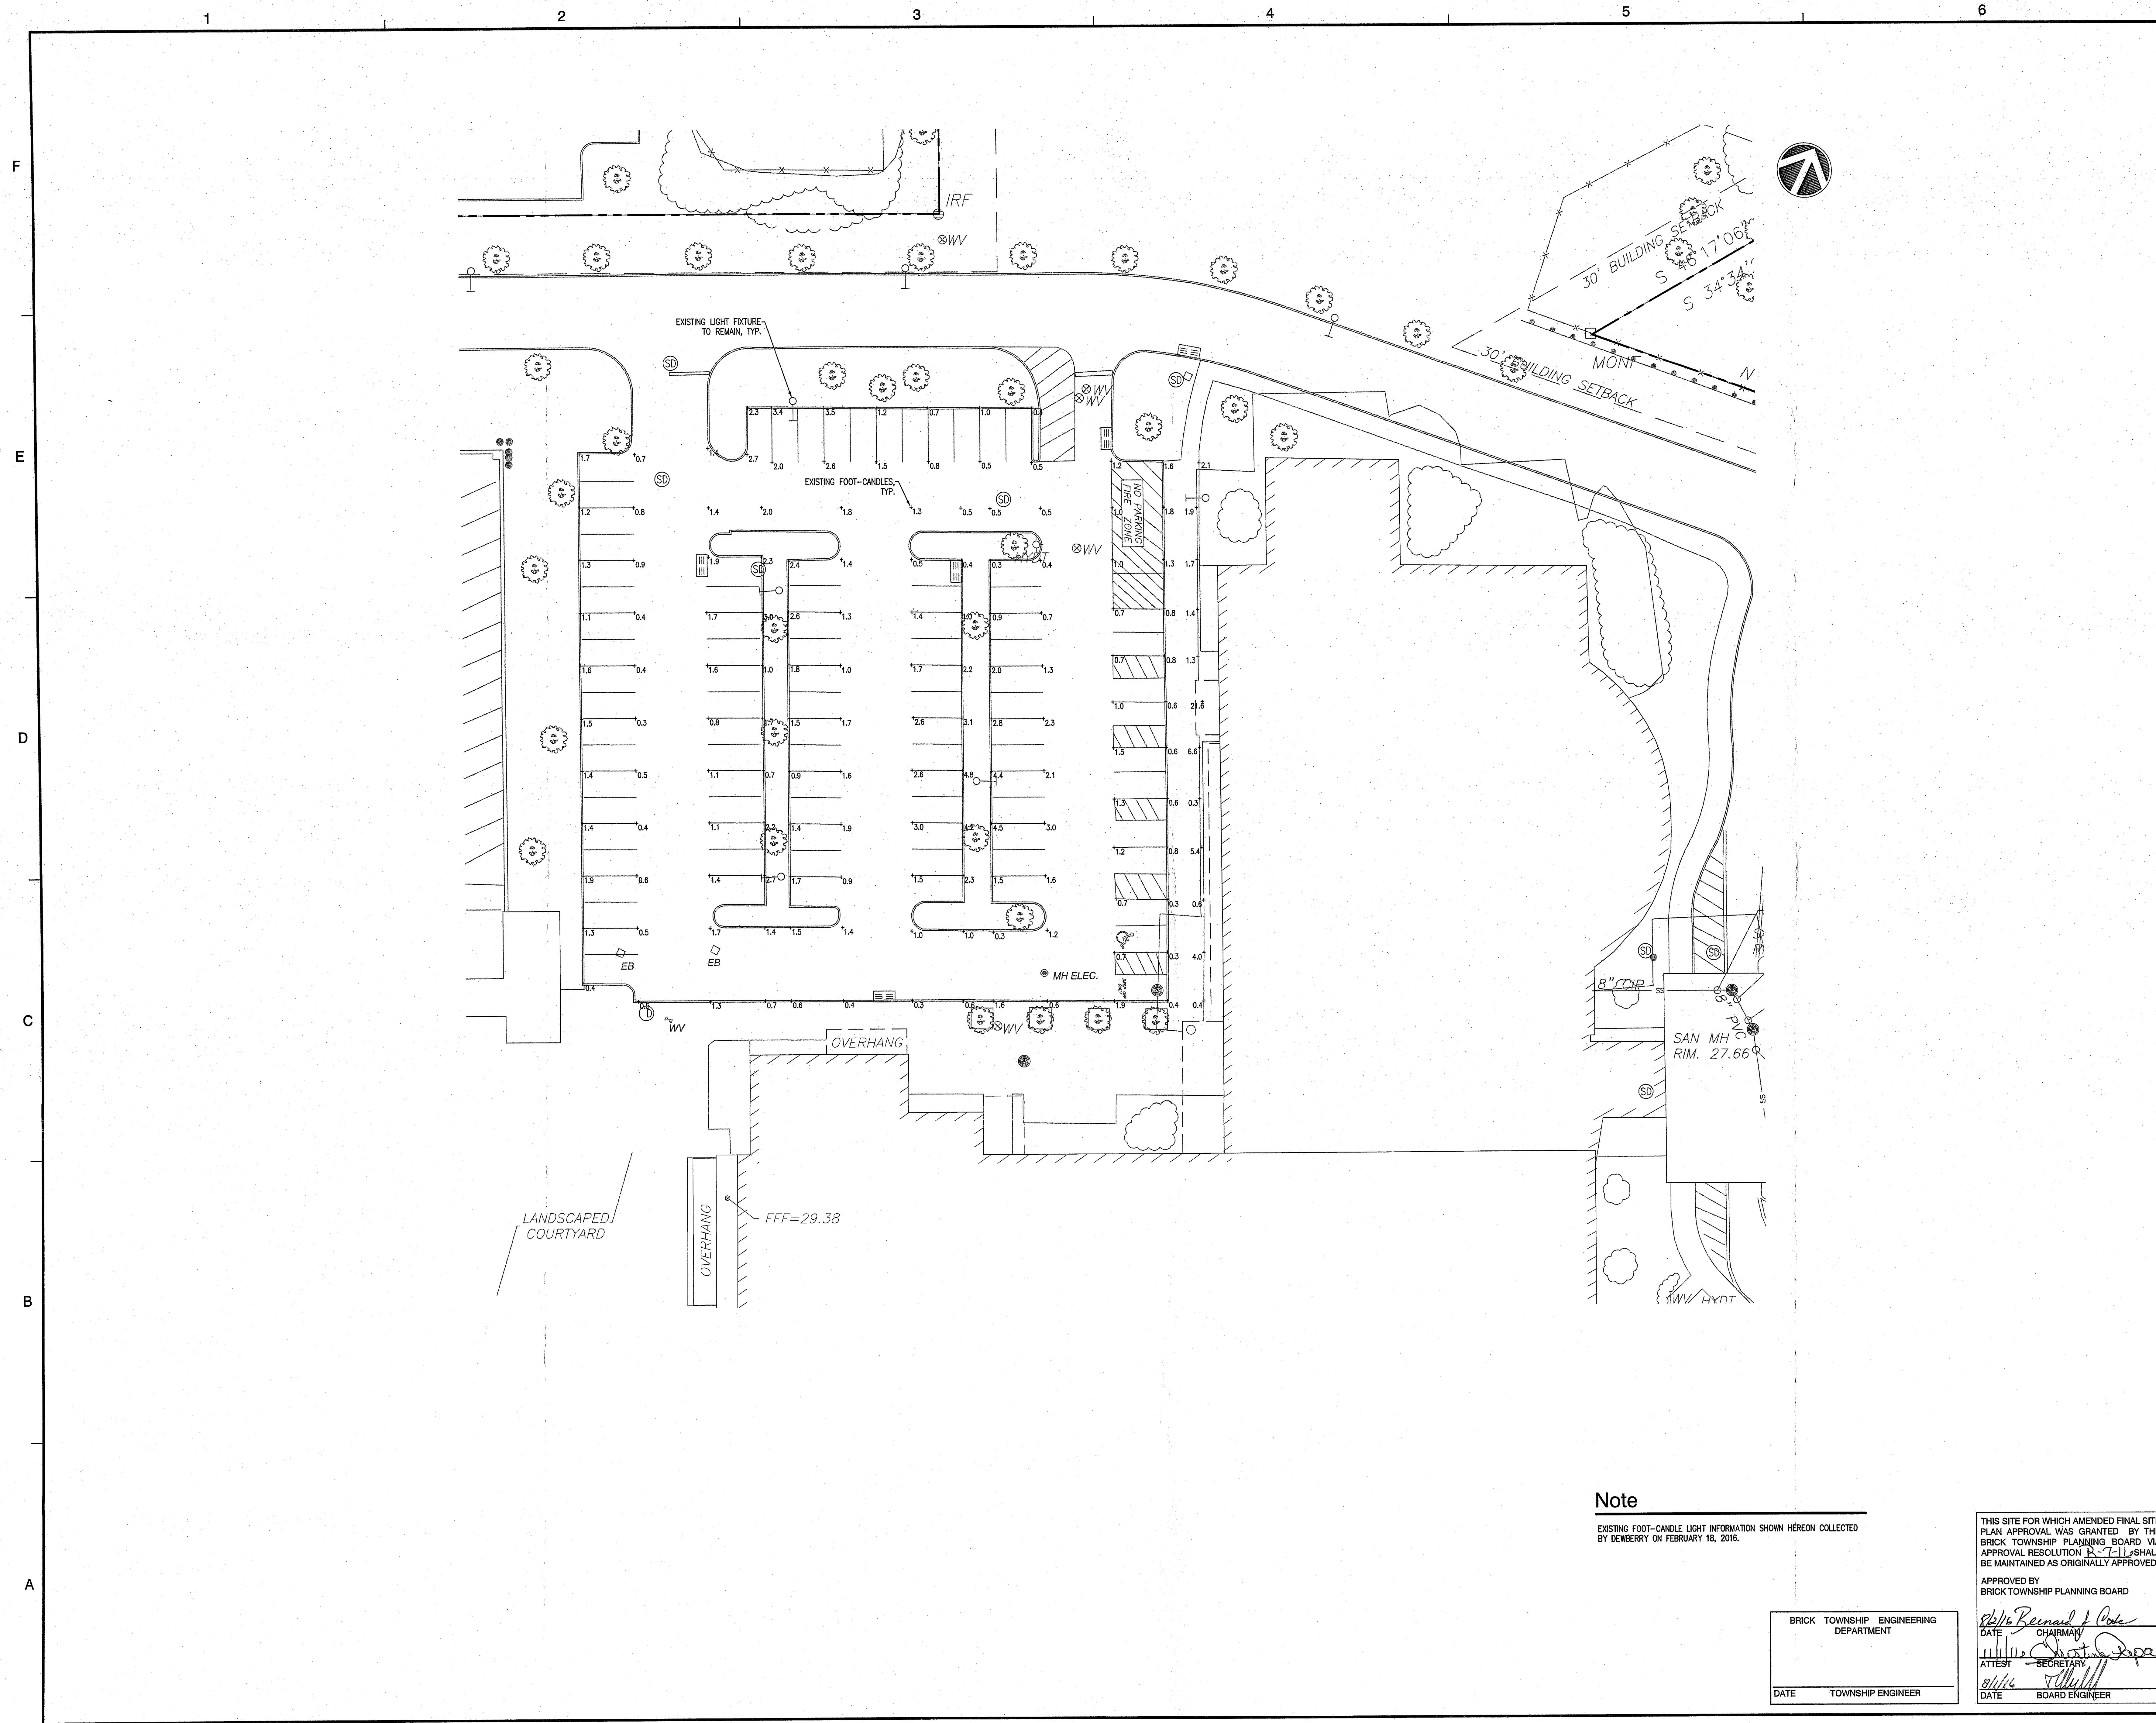

Note
EXISTING FOOT-CANDLE LIGHT INFORMATION SHOWN HEREON COLLECTED BY DEWBERRY ON FEBRUARY 16, 2016.

BRICK TOWNSHIP ENGINEERING
DEPARTMENT
DATE
TOWNSHIP ENGINEER

THIS SITE FOR WHICH AMENDED FINAL SITE PLAN APPROVAL WAS GRANTED BY THE BRICK TOWNSHIP PLANNING BOARD VIA APPROVAL RESOLUTION R-7-11 SHALL BE MAINTAINED AS ORIGINALLY APPROVED.
APPROVED BY
BRICK TOWNSHIP PLANNING BOARD
DATE
CHAIRMAN
ATTEST
SECRETARY
DATE
BOARD ENGINEER

Dewberry Engineers Inc.
600 PARSONS ROAD
SUITE 301
PARSONS, NJ 07054
973.759.9400 Phone
973.759.9710 Fax
Certificate of Authorization #54348047000

Ocean Medical Center
605 JACK MARTIN BOULEVARD
BRICK TOWNSHIP, OCEAN COUNTY, NEW JERSEY

AMENDED FINAL
SITE PLAN FOR
OCEAN MEDICAL CENTER
ONCOLOGY ENTRANCE IMPROVEMENTS
BLOCK 1170, LOTS 18, 18.02

SEAL

Christopher M. Cirrotti, P.E.
New Jersey License No. 24GE0388800
KEY PLAN

SCALE

(IN FEET)
1 inch = 20 ft.

No.	DATE	BY	Description
4	06.07.16	SP	TOWNSHIP COMMENTS
3	05.18.16	SP	TOWNSHIP COMMENTS
2	04.12.16	SP	BOARD ENGINEERS COMMENTS
1	02.22.16	SP	PLD COMMENTS

REVISIONS


DRAWN BY: SLP
APPROVED BY: CC
CHECKED BY: MI
DATE: 08.14.16

TITLE
EXISTING LIGHTING PLAN

PROJECT NO. 50075668

C-103

SHEET NO.

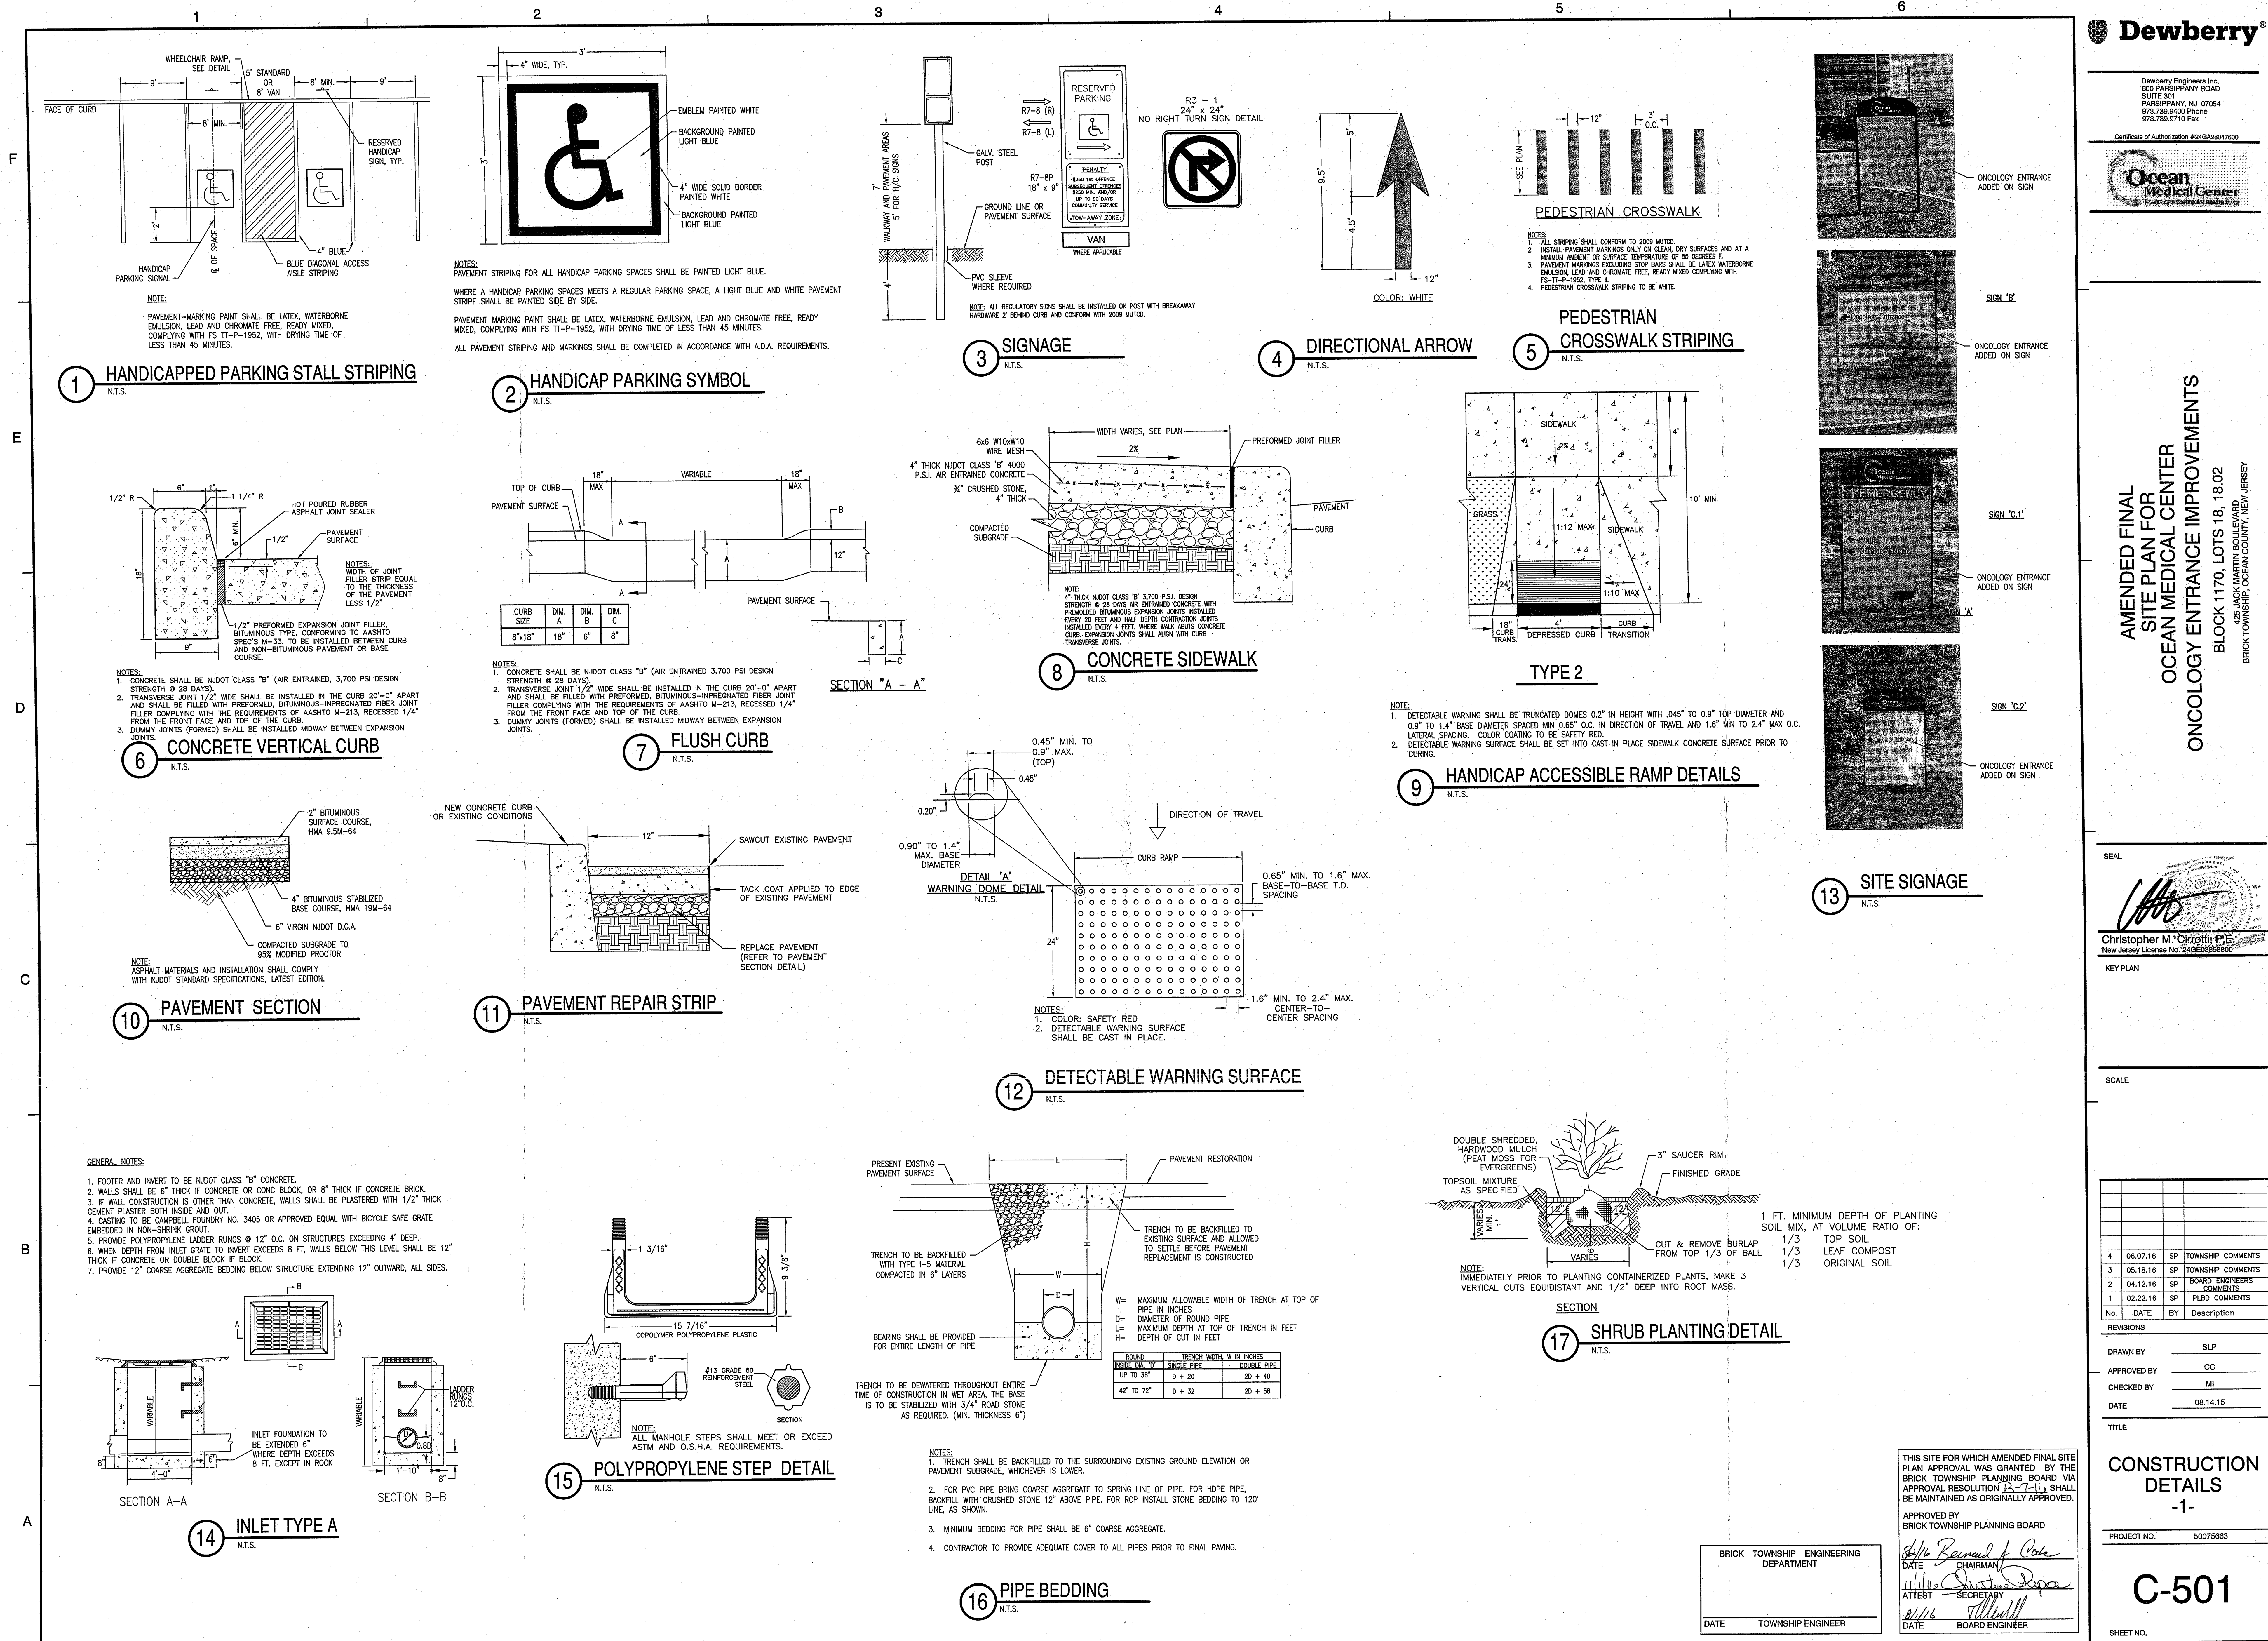

No.	DATE	BY	Description
1	02.22.16	SP	PLANS COMMENTS
2	04.12.16	SP	BOARD ENGINEERS COMMENTS
3	05.18.16	SP	TOWNSHIP COMMENTS
4	06.07.16	SP	TOWNSHIP COMMENTS

REVISIONS

DRAWN BY: SLP

APPROVED BY: CC

CHECKED BY: MI

DATE: 06.14.16

TITLE:

CONSTRUCTION
DETAILS
-1-