

THE MEDICAL CENTER OF OCEAN COUNTY


200' OWNERS LIST

BLOCK	LOT	NAME & ADDRESS	BLOCK	LOT	NAME & ADDRESS
827	4 L5, 6	Dorothy Theofanides P.O. Box 686 Point Pleasant, NJ 08742	1170	21 C305	Kinetic Diagnostic Center, Inc. P.O. Box 1792 Brick, NJ 08723
827	7 L8, 9	Walter & Matilde G. Kullina 1628 W. Princeton Avenue Brick, NJ 08724	1170	21 C306	Kinetic Diagnostic Center, Inc. P.O. Box 1792 Brick, NJ 08723
827	10 L11, 12	Harvey B. & Mildred Morl 1624 W. Princeton Avenue Brick, NJ 08724	1170	21 C307	Kinetic Diagnostic Center, Inc. P.O. Box 1792 Brick, NJ 08723
827	19 L20, 37-40	1617 Route 88 West Associates 1617 Route 88 West Brick, NJ 08724	1170	21 C308	Kinetic Diagnostic Center, Inc. P.O. Box 1792 Brick, NJ 08723
827	21 L22, 23	Richard J. & Maureen Yeager 922 Ocean Avenue Mantoloking, NJ 08758	1170.01	7 L8	Nail & Laurie Rolly 1663 Fairwood Lane Brick, NJ 08724
827	24 L25, 26	Richard J. Yeager 148 Squan Beach Road Mantoloking, NJ 08758	1170.04	8	Theodore E. & Gloria Vetrini 1666 Fairwood Lane Brick, NJ 08724
827	27 L28-30	Erich & Barbara Schmidt P.O. Box 11 Brick, NJ 08723	1170.04	9	Robert D. & Kathleen A. Schmidinger 123 Walter Road Brick, NJ 08724
827	31 L32-36	Berkowitz Enterprises, LLC P.O. Box 4485 Brick, NJ 08723	1170.04	10	Dina M. Mullaano & W.M. Barbato 127 Walter Road Brick, NJ 08724
830	31 L32-40	Dominick & Aldo Incolin 42 Gertrude Place Manasquan, NJ 08756	1170.04	11	Stephen D. & Christine M. Fawkes 131 Walter Road Brick, NJ 08724
1150	1 L2, 3, 5	Laurelton Gardens Co. Operative Inc. 1010 Route 70 Brick, NJ 08724	1170.04	12	Nicholas & Laura Cordiale 135 Walter Road Brick, NJ 08724
1163.12	1	John M. & Margaret M. Diehl 50 Frank Neri Drive Brick, NJ 08724	1170.04	13	Margaret J. Morse 136 Walter Road Brick, NJ 08724
1163.12	5	Charles Marzula 613 Hill Drive Brick, NJ 08724	1170.04	14	George M. & Barbara Ann Wheeler 143 Sherwood Lane Brick, NJ 08724
1163.12	9 L10, 11	Robert F. & Sharon M. Coon 52 Frank Neri Drive Brick, NJ 08724	1170.05	1	Allen A. & Debbie A. Justino 110 Walter Road Brick, NJ 08724
1163.12	21 L22, 23	Robert & Rosemary Zullo 53 Albert Cusci Drive Brick, NJ 08724	1170.05	2	Steven J. & Vera Lichtenberger 122 Walter Road Brick, NJ 08724
1168.07	1	ACM International Leasing Corp., Inc. 450 Jack Martin Boulevard Brick, NJ 08724	1170.05	3	Joan Frances Dillon 128 Walter Road Brick, NJ 08724
1170	18.01	Ocean County 101 Hooper Avenue Toms River, NJ 08753	1170.05	4	Michael & Marie Dineo et al 132 Walter Road Brick, NJ 08724
1170	18.03	Ocean Nursing Pavilion, Inc. 212 Edgewater Place Point Pleasant, NJ 08742-2290	1170.05	5	Richard C. & Lisa K. Heerwagen 136 Walter Road Brick, NJ 08724
1170	19.01	88 Brick II LLC 900 Route 9 North Woodbridge, NJ 07095	1170.05	6	Enrico R. & Linda A. Stefanelli 144 Walter Road Brick, NJ 08724
1170	19.01	Coastal Realty Company, LLC 9 Hospital Drive Toms River, NJ 08753	1170.06	8	Peter Zazula 179 John Street Brick, NJ 08724
1170	19.01	Harvey A. & Doris E. Collins, Jr. 1608 Highway 88 West Brick, NJ 08724	1170.07	6	Thomas Mortellaro 151 Walter Road Brick, NJ 08724
1170	19.01	Hogit Morgan 1568 Beaver Hollow Drive Toms River, NJ 08753	1170.07	7	Wayne L. & Bonnie L. Burr 155 Walter Road Brick, NJ 08724
1170	19.01	Anthony & Cynthia J. Leo 11 Steneham Drive Brick, NJ 08724	1170.07	8	Phillip Deshmon 159 Walter Road Brick, NJ 08724
1170	19.02	Brick Medical Mall, Inc. 1075 Route 34, Suite G Absecon, NJ 07747	1170.07	9	Brian A. & Anthe E. Jones 163 Walter Road Brick, NJ 08724
1170	21 C101	Kinetic Diagnostic Center, Inc. P.O. Box 1792 Brick, NJ 08723	1170.07	10	Ruth Carol Neal 165 Walter Road Brick, NJ 08724
1170	21 C201	KDC Partners 457 Jack Martin Boulevard Brick, NJ 08724	1170.08	1	Aardvark Enterprises 158 Walter Road Brick, NJ 08724
1170	21 C202	Kinetic Diagnostic Center, Inc. P.O. Box 1792 Brick, NJ 08723	1170.08	2	Lettie Brower Quaman 158 Walter Road Brick, NJ 08724
1170	21 C203	JNM LLC c/o Fitness in Therapy 2164 Route 35 Sea Girt, NJ 08750	1170.08	3	Paula L. Burns 160 Walter Road Brick, NJ 08724
1170	21 C204	Kinetic Diagnostic Center, Inc. P.O. Box 1792 Brick, NJ 08723	1170.08	4	Joseph L. & Michele Vandevender 164 Walter Road Brick, NJ 08724
1170	21 C205	Oreal Associates 457 Jack Martin Boulevard, #205 Brick, NJ 08724	1170.08	5	Charles R. & Rosemarie Stuerze 168 Walter Road Brick, NJ 08724
1170	21 C301	Kinetic Diagnostic Center, Inc. P.O. Box 1792 Brick, NJ 08723	1170.08	6	Keith & Catherine Fensler 172 Walter Road Brick, NJ 08724
1170	21	Kinetic Diagnostic Center, Inc. P.O. Box 1792C302 Brick, NJ 08723			NUDOT 1035 Parkway Avenue Trenton, NJ 08618
1170	21 C303	Kinetic Diagnostic Center, Inc. P.O. Box 1792 Brick, NJ 08723			Ocean County Planning Board 129 Hooper Avenue Toms River, NJ 08753
1170	21 C304	Kinetic Diagnostic Center, Inc. P.O. Box 1792 Brick, NJ 08723			Garden State Parkway NJ Highway Authority Woodbridge, NJ 07096


TOWNSHIP OF BRICK

OCEAN COUNTY


NEW JERSEY

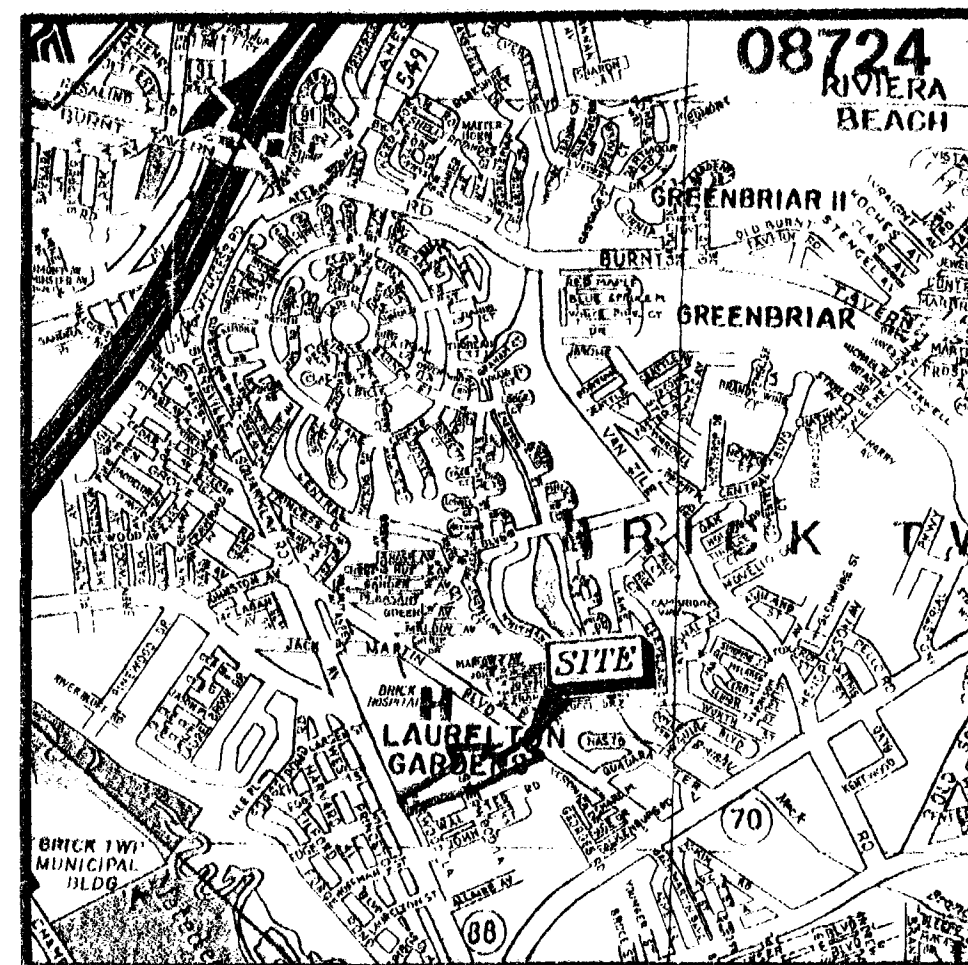

ROAD MAP
1"=2,100'

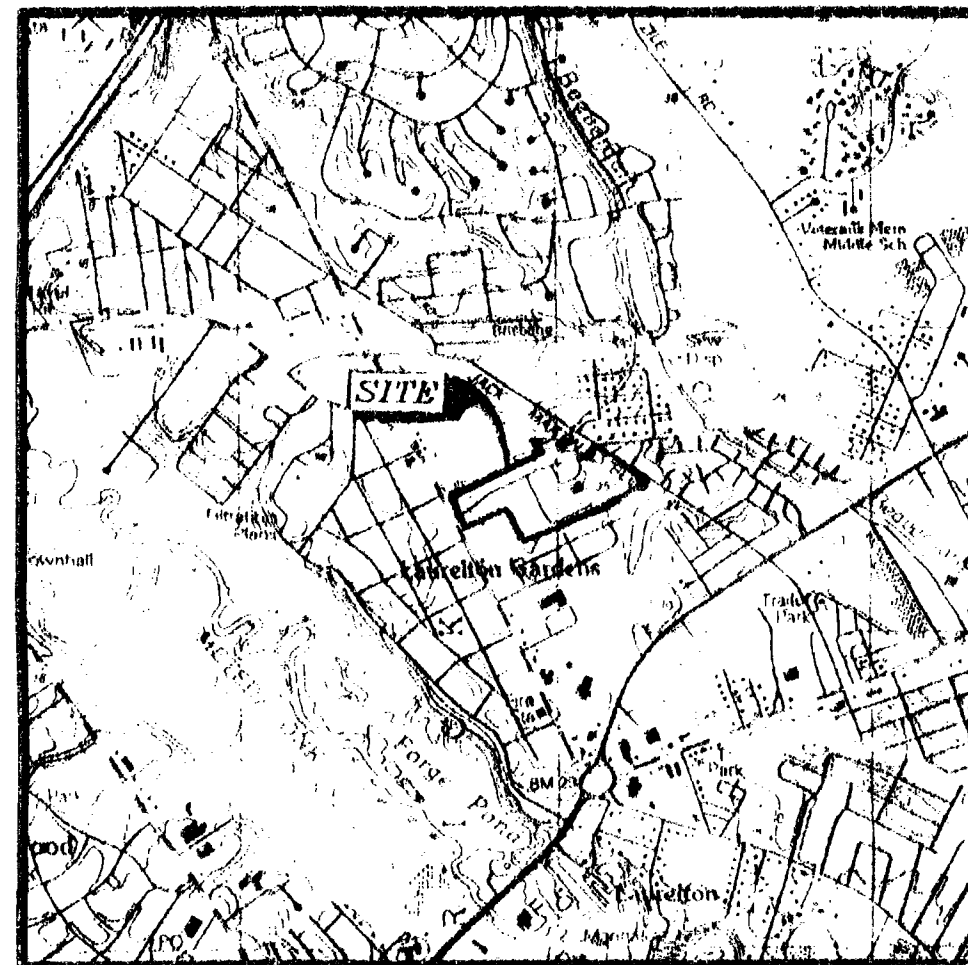

U.S.G.S. MAP
1"=2,000'

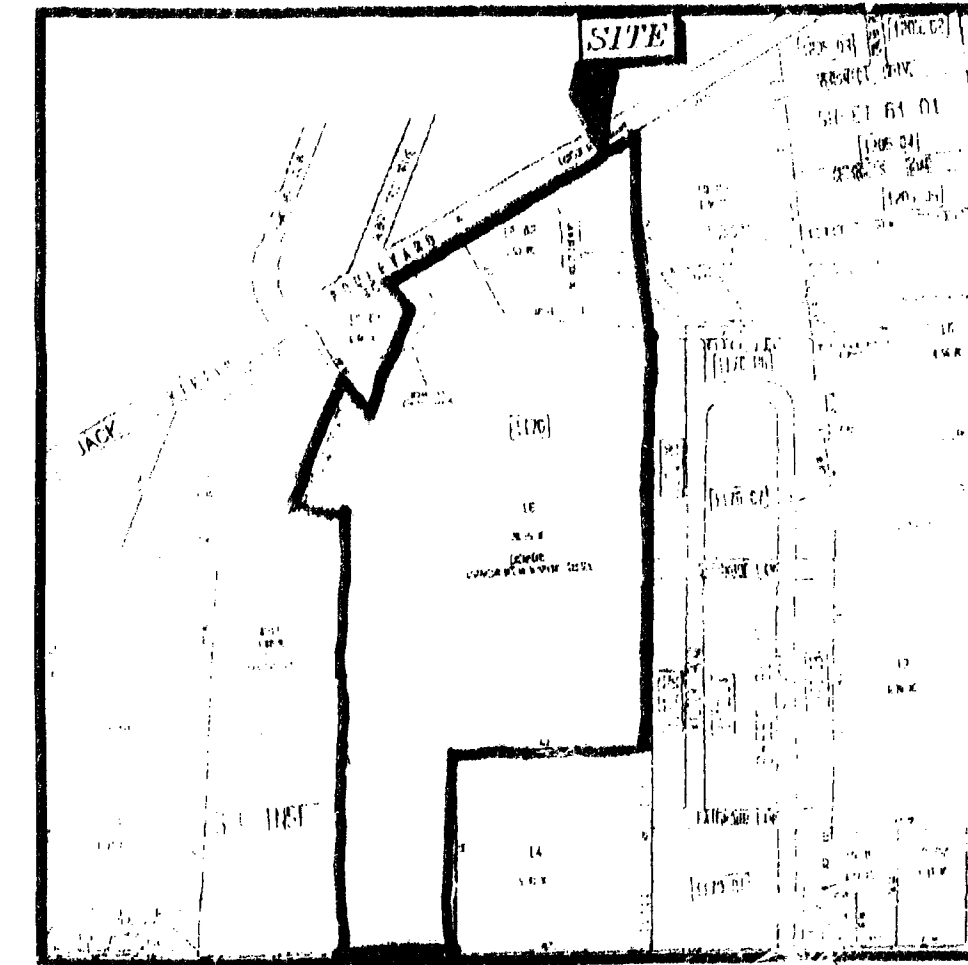

TAX MAP
1"=700'



ZONING MAP
1"=2,000'

DRAWING LIST PLANS PREPARED BY MENLO ENGINEERING ASSOCIATES, INC.

DWG. #	TITLE
CV-1	COVER SHEET
EOP-1	EXISTING OVERALL PLAN
OP-1	OVERALL PLAN
DM-1	DEMOLITION PLAN
GE-1	GEOMETRY PLAN
SGN-1	SIGNAGE PLAN
GU-1	GRADING & UTILITY PLAN-1
GU-2	GRADING & UTILITY PLAN-2
CS-1	CONSTRUCTION STAGING PLAN-1
CS-2	CONSTRUCTION STAGING PLAN-2
LA-1	LANDSCAPING PLAN-1
LA-2	LANDSCAPING PLAN-2
LI-1	LIGHTING PLAN-1
LI-2	LIGHTING PLAN-2
SE-1	SOIL EROSION & SEDIMENT CONTROL PLAN
UP-1	UTILITY PROFILES
DE-1	DETAIL SHEET-1
DE-2	DETAIL SHEET-2
DE-3	DETAIL SHEET-3
DE-4	DETAIL SHEET-4

OWNER & APPLICANT:
THE MEDICAL CENTER OF OCEAN COUNTY
425 JACK MARTIN BOULEVARD
BRICK, NEW JERSEY 08724

1170 / 18 / 1802

THIS IS TO CERTIFY THAT THE WATER AND SEWER MAIN DESIGN CONFORMS WITH THE RULES AND REGULATIONS OF THE BRICK TOWNSHIP MUNICIPAL UTILITIES AUTHORITY.

STEPHEN T. SPECCHI, P.E.
DIRECTOR OF ENGINEERING

DATE

DATE

THE SITE FOR WHICH SITE PLAN APPROVAL WAS GRANTED BY THE TOWNSHIP OF BRICK PLANNING BOARD VIA RESOLUTION 11-42-02 SHALL BE MAINTAINED AS ORIGINALLY APPROVED. 4-24-02

APPROVED BY

CHAIRMAN	9/27/02	DATE
SECRETARY	9-27-02	DATE
BOARD ENGINEER	9-26-02	DATE
MUNICIPAL ENGINEER		DATE

DATE OF ISSUE: FEBRUARY 14, 2002 REVISED THROUGH JUNE 20, 2002



MENLO ENGINEERING ASSOCIATES, INC.

CIVIL ENGINEERING CONSULTANTS & PROFESSIONAL PLANNERS
261 CLEVELAND AVENUE, HIGHLAND PARK, NEW JERSEY 08904
JOB No. 2001.039 DWG. No. CV-1