




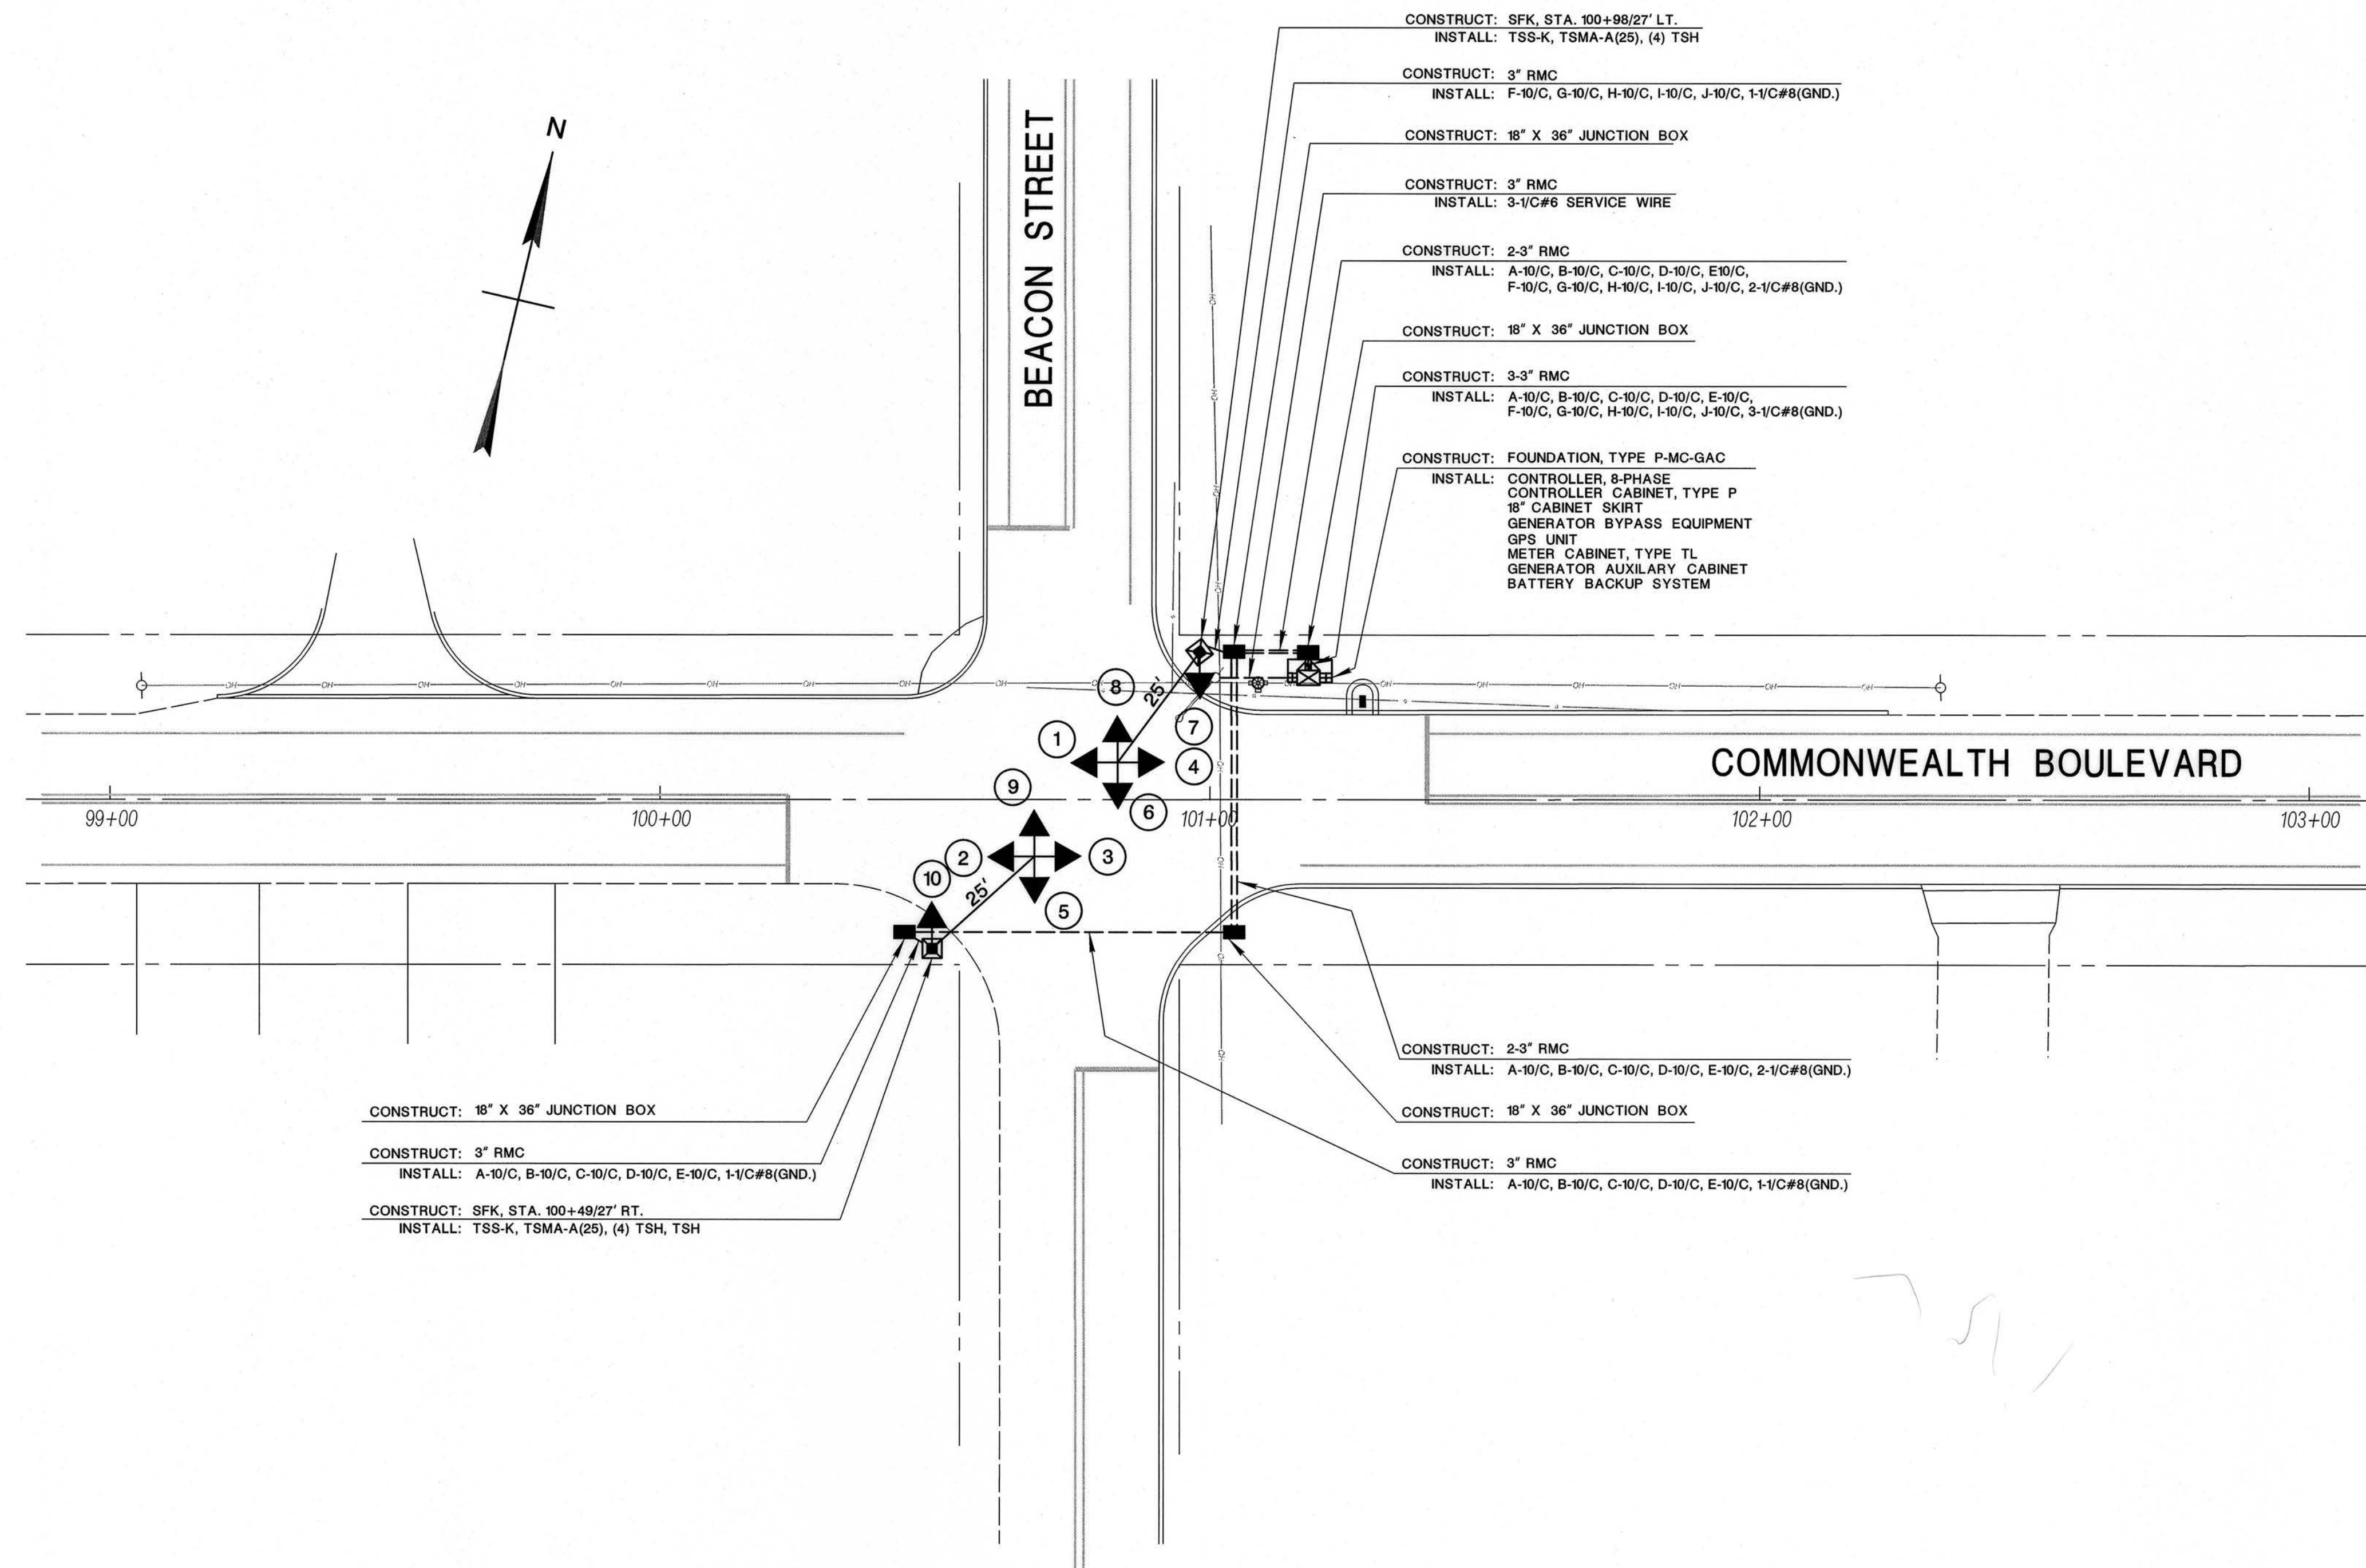


BLOCK WIRING DIAGRAM

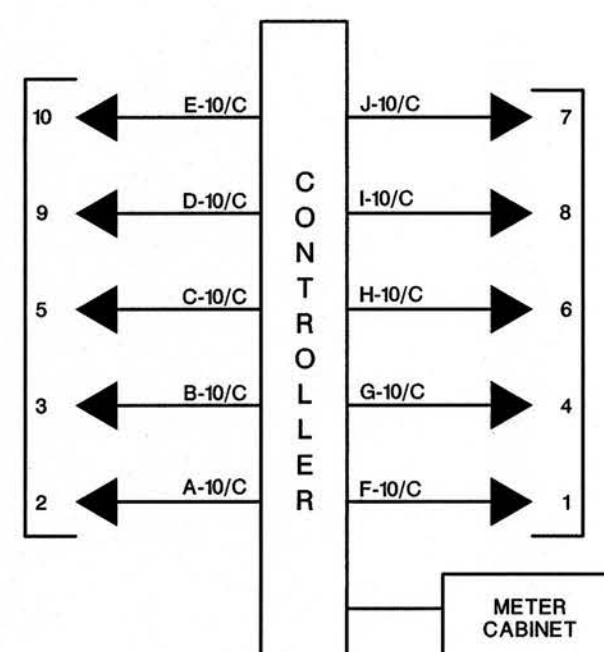

- GENERAL NOTES:**
- THE DESIGN AND INSTALLATION OF THIS SIGNAL HAS BEEN ACCOMPLISHED IN ACCORDANCE WITH THE CURRENT MANUAL ON UNIFORM TRAFFIC CONTROL DEVICES FOR STREETS AND HIGHWAYS (MUTCD).
 - RIGHT OF WAY IS ESTIMATED FROM TAX MAPS.

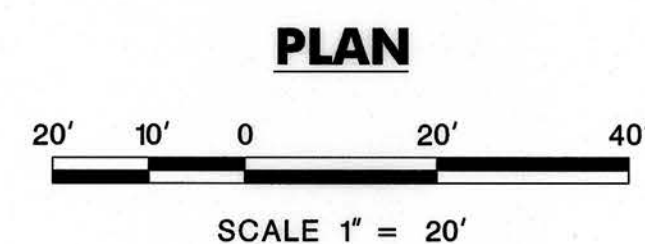

SIGNAL LEGEND

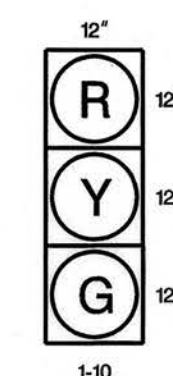

NOTE: HEAD #7 IS MOUNTED AT 10'.

DATE		REVISIONS		BY	CHK.
JOHN N. ERNST COUNTY ENGINEER					
(MAN-20) C.R. 8 COMMONWEALTH BOULEVARD AND C.R. 10 BEACON STREET MANCHESTER TOWNSHIP					
ELECTRICAL PLAN					
FLD.BK.	DATE	DESIGNED	NAT	CHECKED	
	JULY 2024				
SCALE	1"=20'	DRAWN	LG	APPROVED	
FILE NO.	19 008 102			SHEET 2 OF 2	

19 008 0903A